


PROPOSED GOOF GUDUUD FOOTBALL FIELD

GRANT NO. BAI045



ARCHITECTS

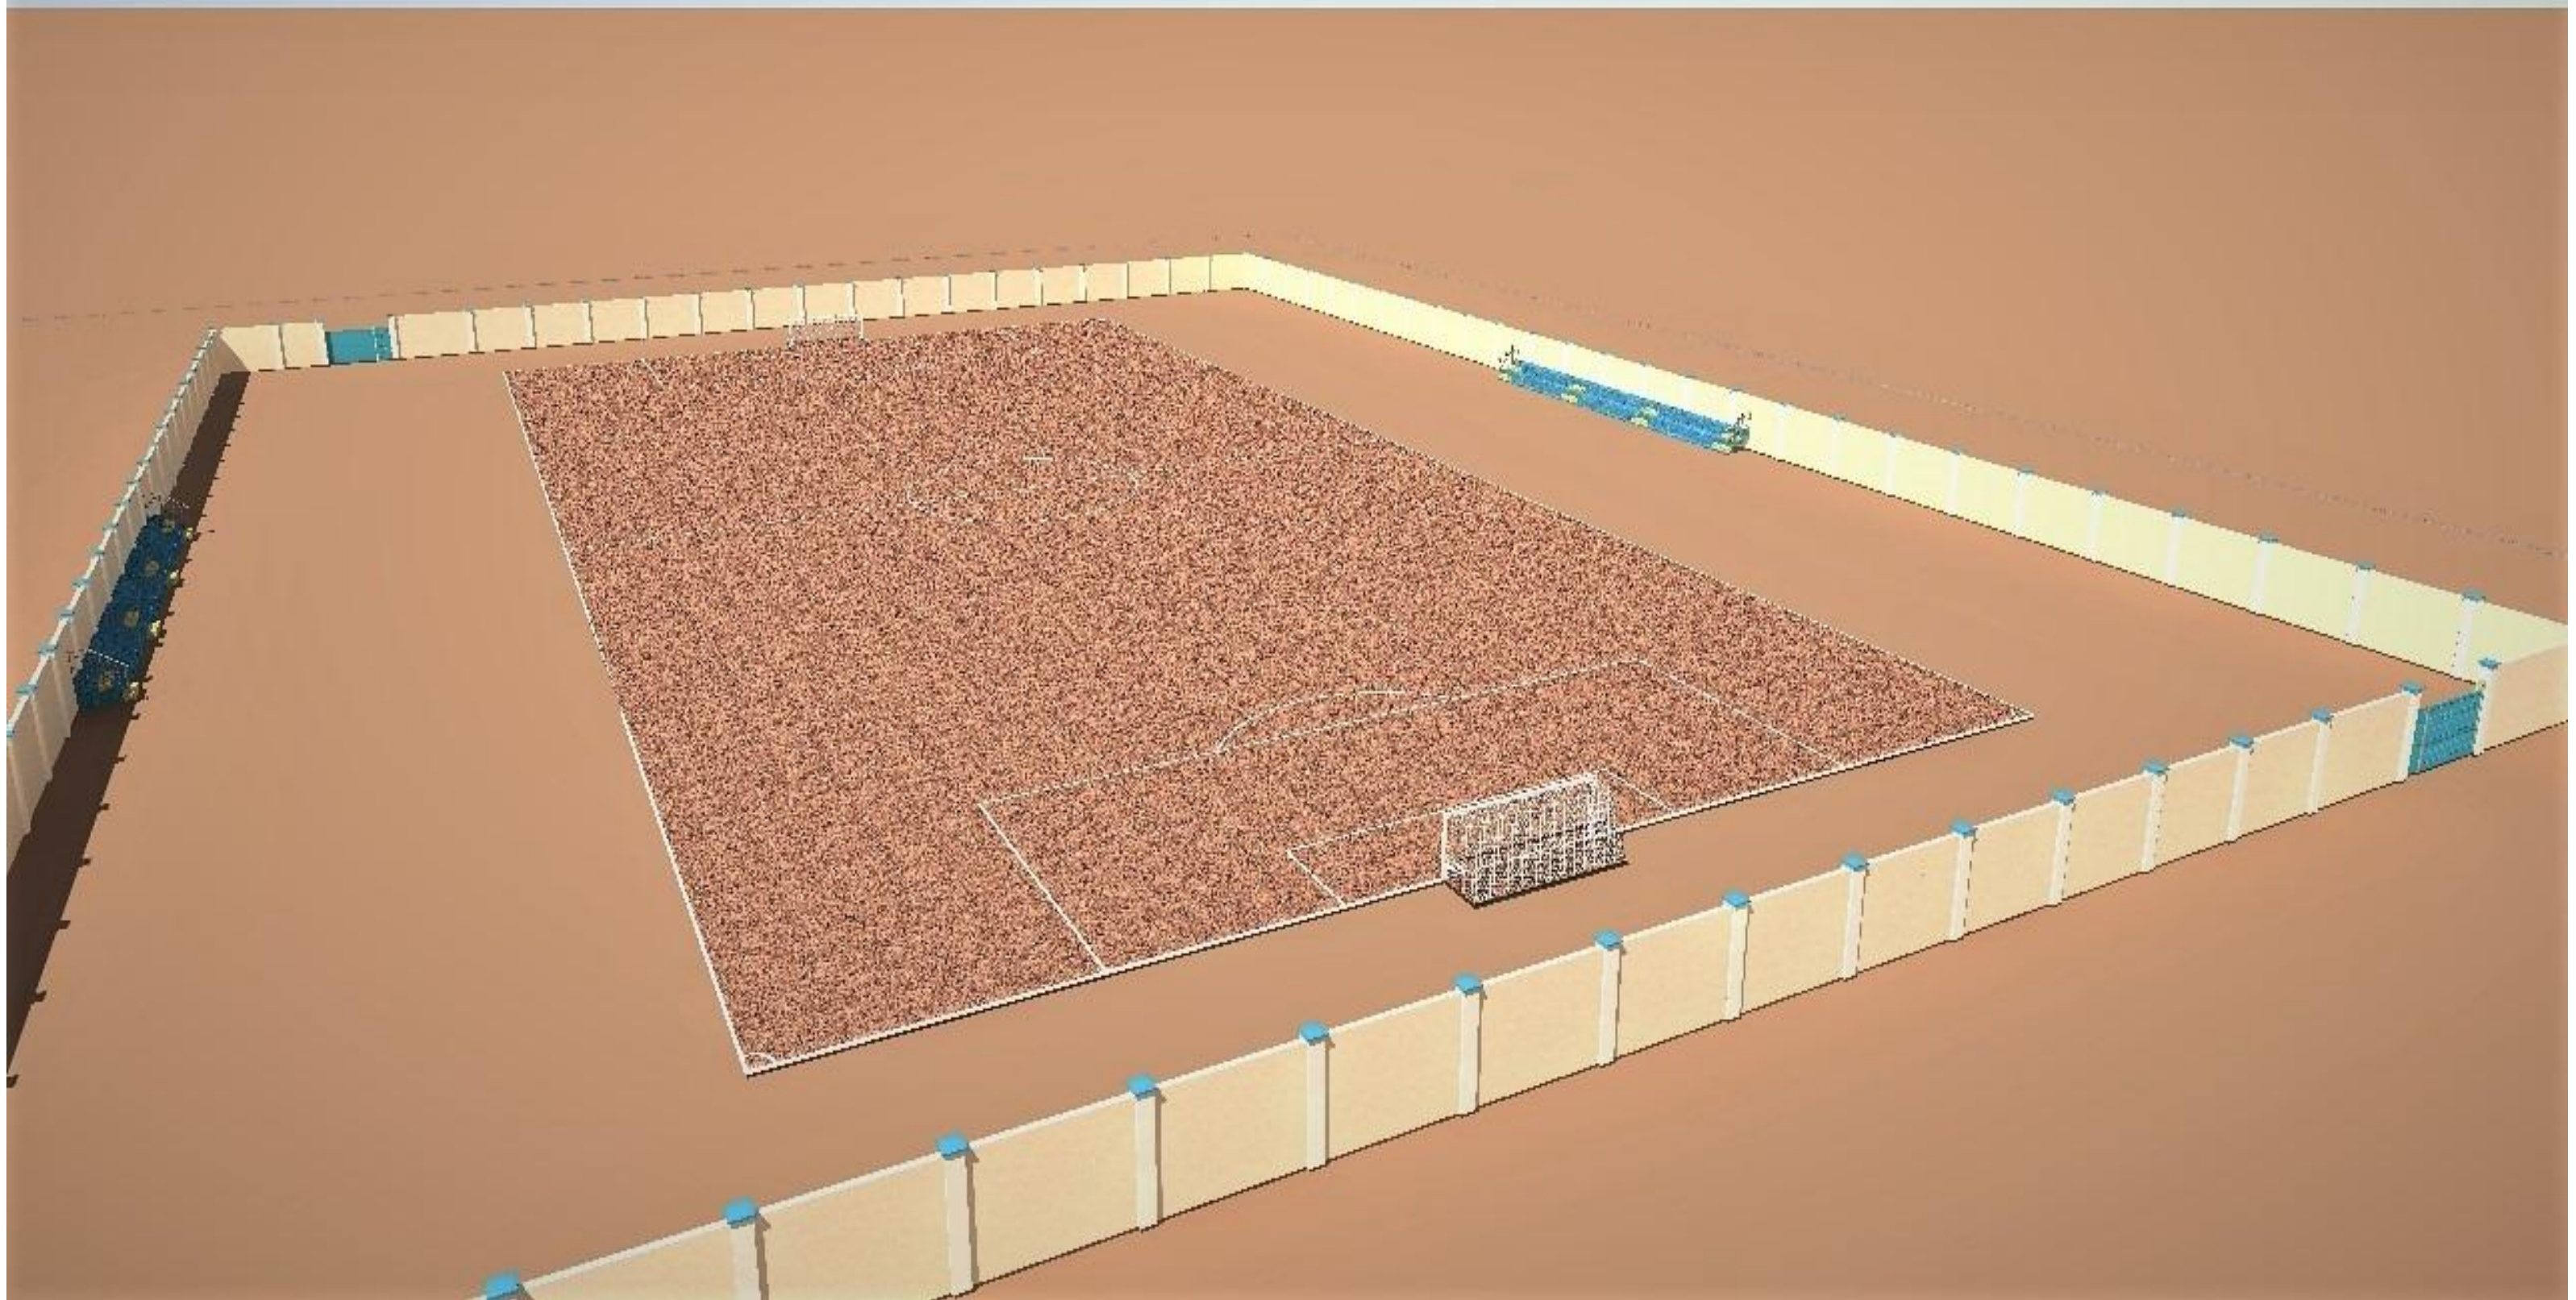

GeConsult
ARCHITECTURE & ENGINEERING CONSULTANTS
 Office No. 529,
 5th Floor, 680 Hotel Building,
 Muindi Mbingu Street,
 Off Kenyatta Avenue,
 geconsultteam@gmail.com
 www.geconsultarchitects.com
 P.O Box 103525 - 00101 Nairobi, Kenya
 Tel: +254 724 008 839 / +254 725 178 875

PROJECT DETAILS

Client:



**SOUTH WEST
 STATE
 ADMINISTRATION**

Implementation Partner:

**SOMALIA STABILIZATION
 INITIATIVE (SSI)**

Project title:

**PROPOSED GOOF GUDUUD
 FOOTBALL FIELD**

Grant No.:

BAI045

Content :

**ARCHITECTURAL
 DRAWINGS**



PROPOSED GOOF GUDUUD FOOTBALL FIELD

GRANT NO. BAI045

SHEET NO.	CONTENTS
01	GPS COORDINATES
02	SITE PLAN
03	SET OUT PLAN
04	SPECTATOR STANDS DETAILS
05	FENCE DETAIL
3D-01	3 DIMENSIONAL PROJECTION 01
3D-02	3 DIMENSIONAL PROJECTION 02
3D-03	3 DIMENSIONAL PROJECTION 03
3D-04	3 DIMENSIONAL PROJECTION 04
3D-05	3 DIMENSIONAL PROJECTION 05

ARCHITECTS



GeConsult
ARCHITECTURE & ENGINEERING CONSULTANTS
Office No. 529,
5th Floor, 680 Hotel Building,
Muindi Mbingu Street,
Off Kenyatta Avenue,
geconsultteam@gmail.com
www.geconsultarchitects.com
P.O Box 103525 - 00101 Nairobi, Kenya
Tel: +254 724 008 839 / +254 725 178 875

PROJECT DETAILS

Client:



Implementation Partner:

SOMALIA STABILIZATION
INITIATIVE (SSI)

Project title:

PROPOSED GOOF GUDUUD
FOOTBALL FIELD

Grant No.:


BAI045

Content :

ARCHITECTURAL
DRAWINGS



ARCHITECTS

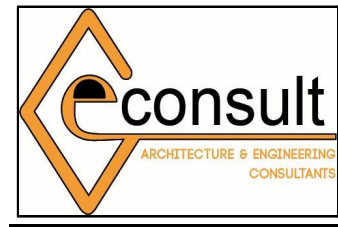

GeConsult
ARCHITECTURE & ENGINEERING CONSULTANTS
Office No. 529,
5th Floor, 680 Hotel Building,
Muindi Mbingu Street,
Off Kenyatta Avenue,
geconsultteam@gmail.com
www.geconsultarchitects.com
P.O Box 103525 - 00101 Nairobi, Kenya
Tel: +254 724 008 839 / +254 725 178 875

PROJECT DETAILS

Client:



**SOUTH WEST
STATE
ADMINISTRATION**


Implementation Partner:

**SOMALIA STABILIZATION
INITIATIVE (SSI)**

Project title:

**PROPOSED GOOF GUDUUD
FOOTBALL FIELD**

Drawing Title:		Revision No.	
GPS COORDINATES		01	
Drawn by:	Checked by:	Sheet No.	Scale:
A.K.	Hassan Abdisamad	01	N/A
Date:	July 2017	ARCHITECTURAL DRAWINGS	

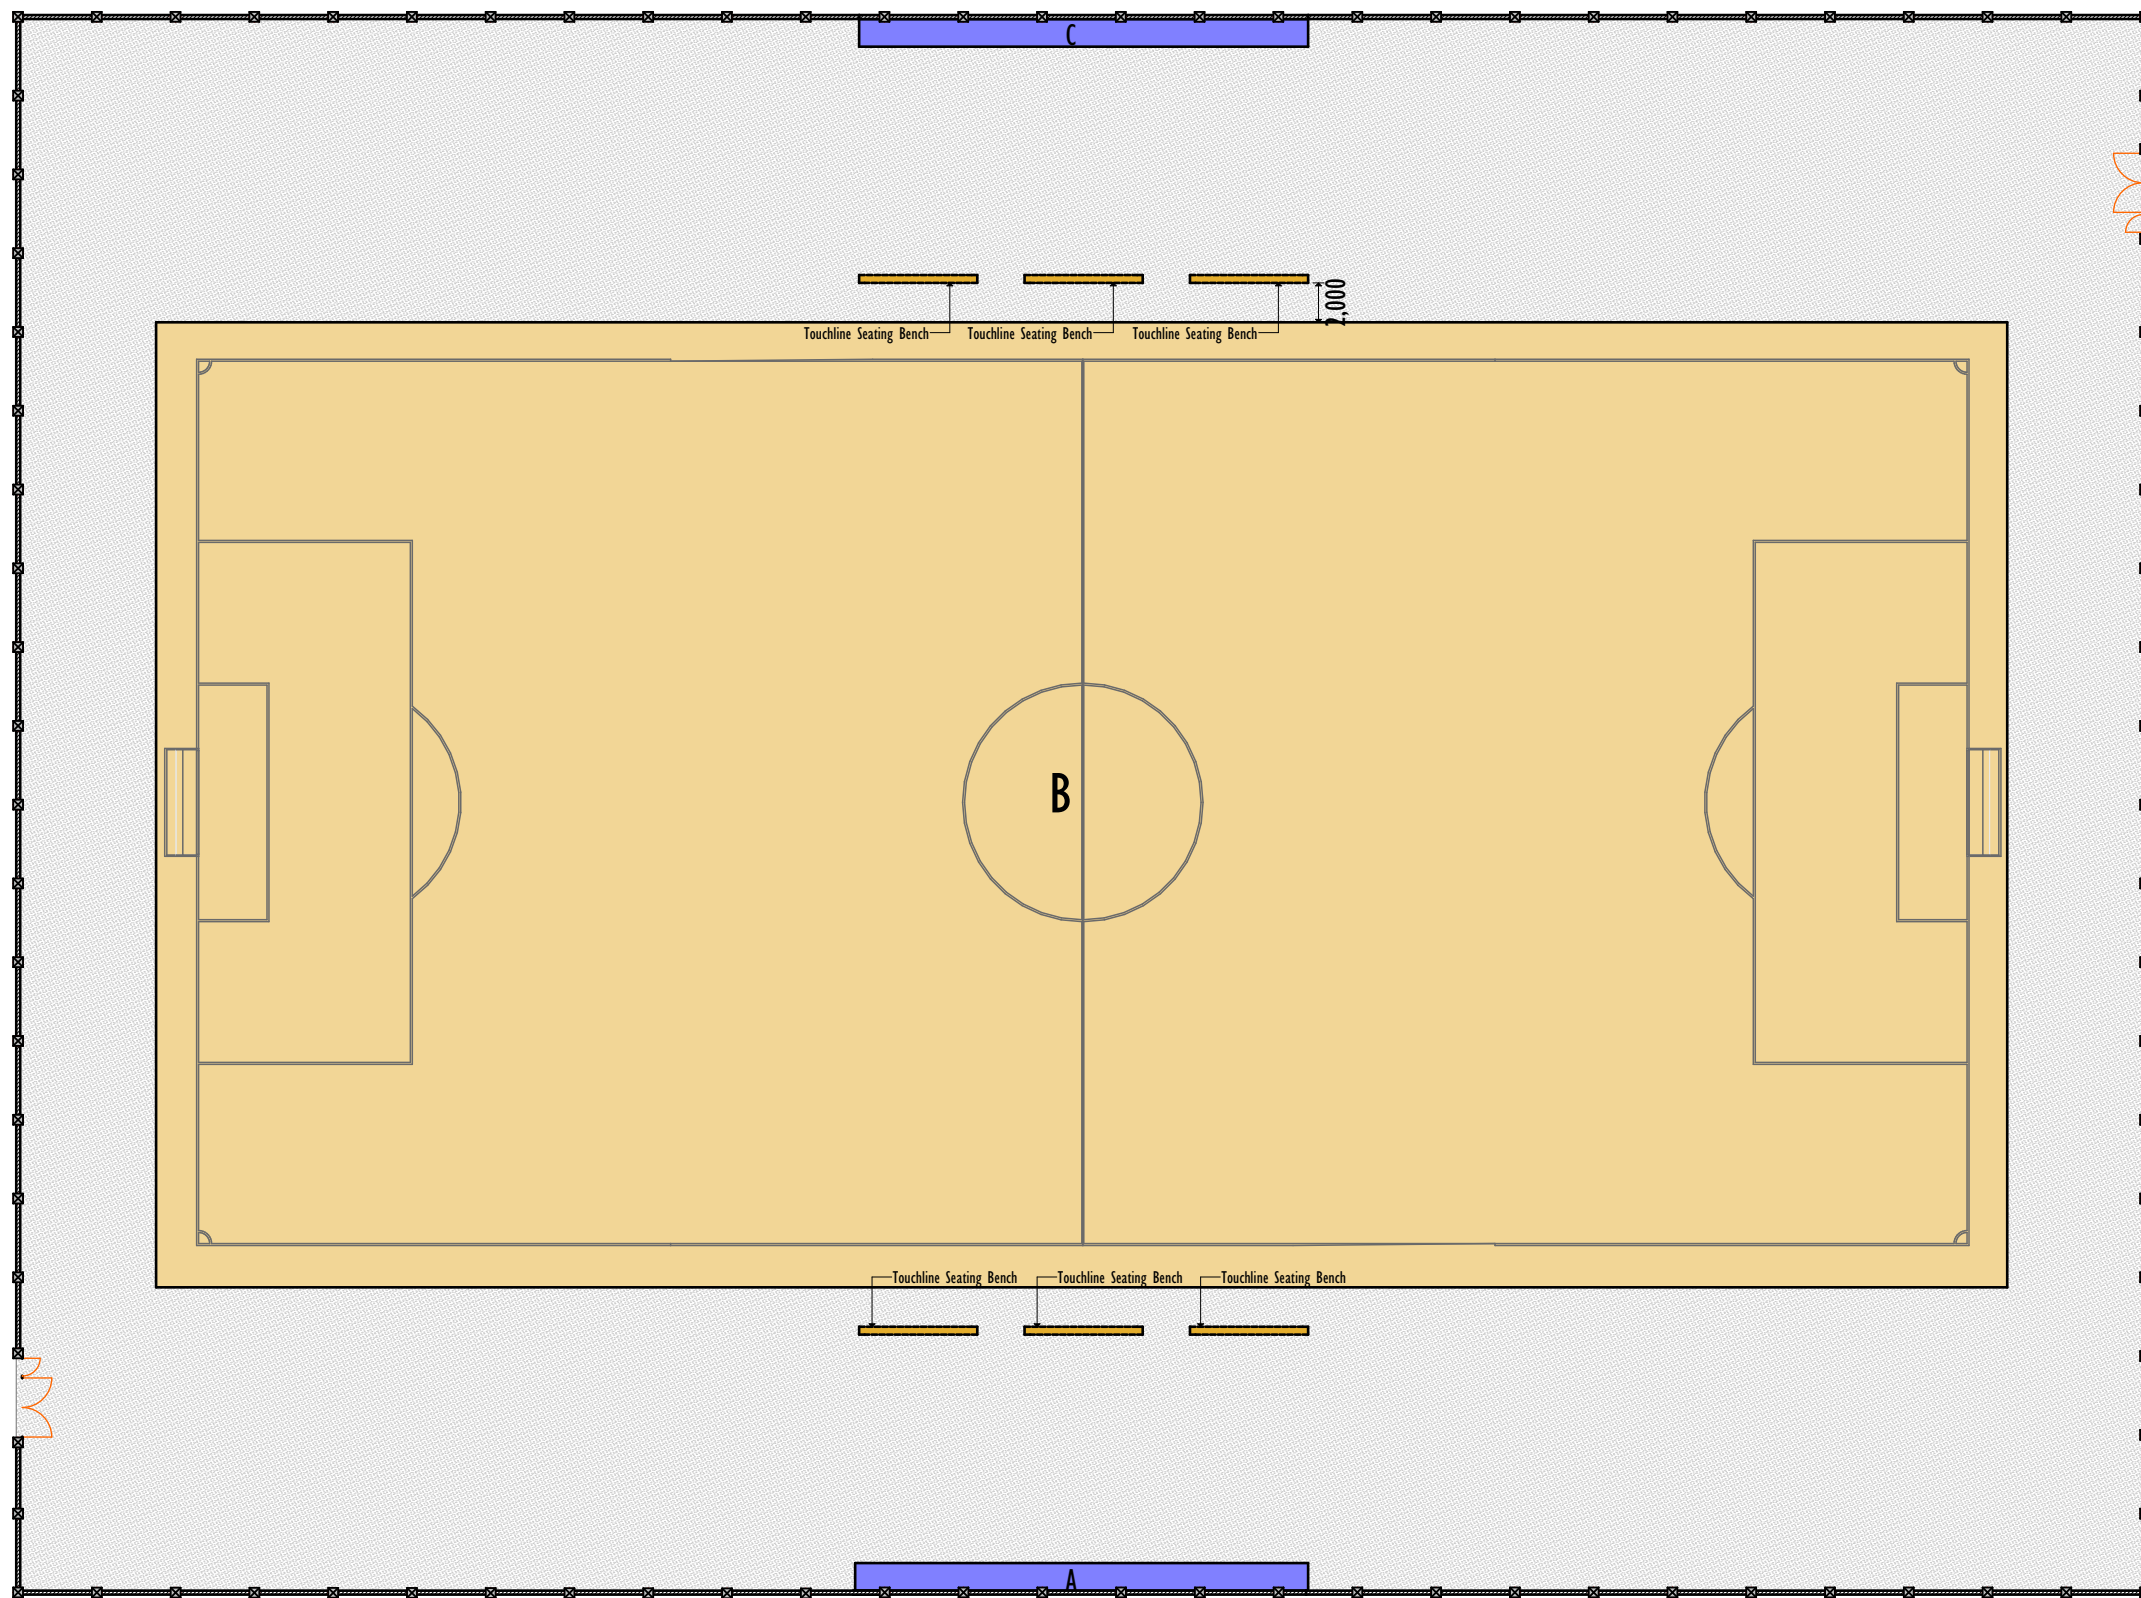

LEGEND

A	SPECTATOR STANDS-01
B	FOOTBALL PITCH
C	SPECTATOR STANDS-02

ARCHITECTS



GeConsult
ARCHITECTURE & ENGINEERING CONSULTANTS
 Office No. 529,
 5th Floor, 680 Hotel Building,
 Muindi Mbingu Street,
 Off Kenyatta Avenue,
 geconsultteam@gmail.com
 www.geconsultarchitects.com
 P.O Box 103525 - 00101 Nairobi, Kenya
 Tel: +254 724 008 839 / +254 725 178 875

PROJECT DETAILS

Client:



**SOUTH WEST
 STATE
 ADMINISTRATION**

Implementation Partner:

**SOMALIA STABILIZATION
 INITIATIVE (SSI)**

Project title:

**PROPOSED GOOF GUDUUD
 FOOTBALL FIELD**

Drawing Title:

SITE PLAN

Drawn by:

A.K.

Date:

July 2017

Checked by:

Hassan Abdisamad

Revision No.


01

Sheet No.

02

Scale:

ARCHITECTURAL DRAWINGS

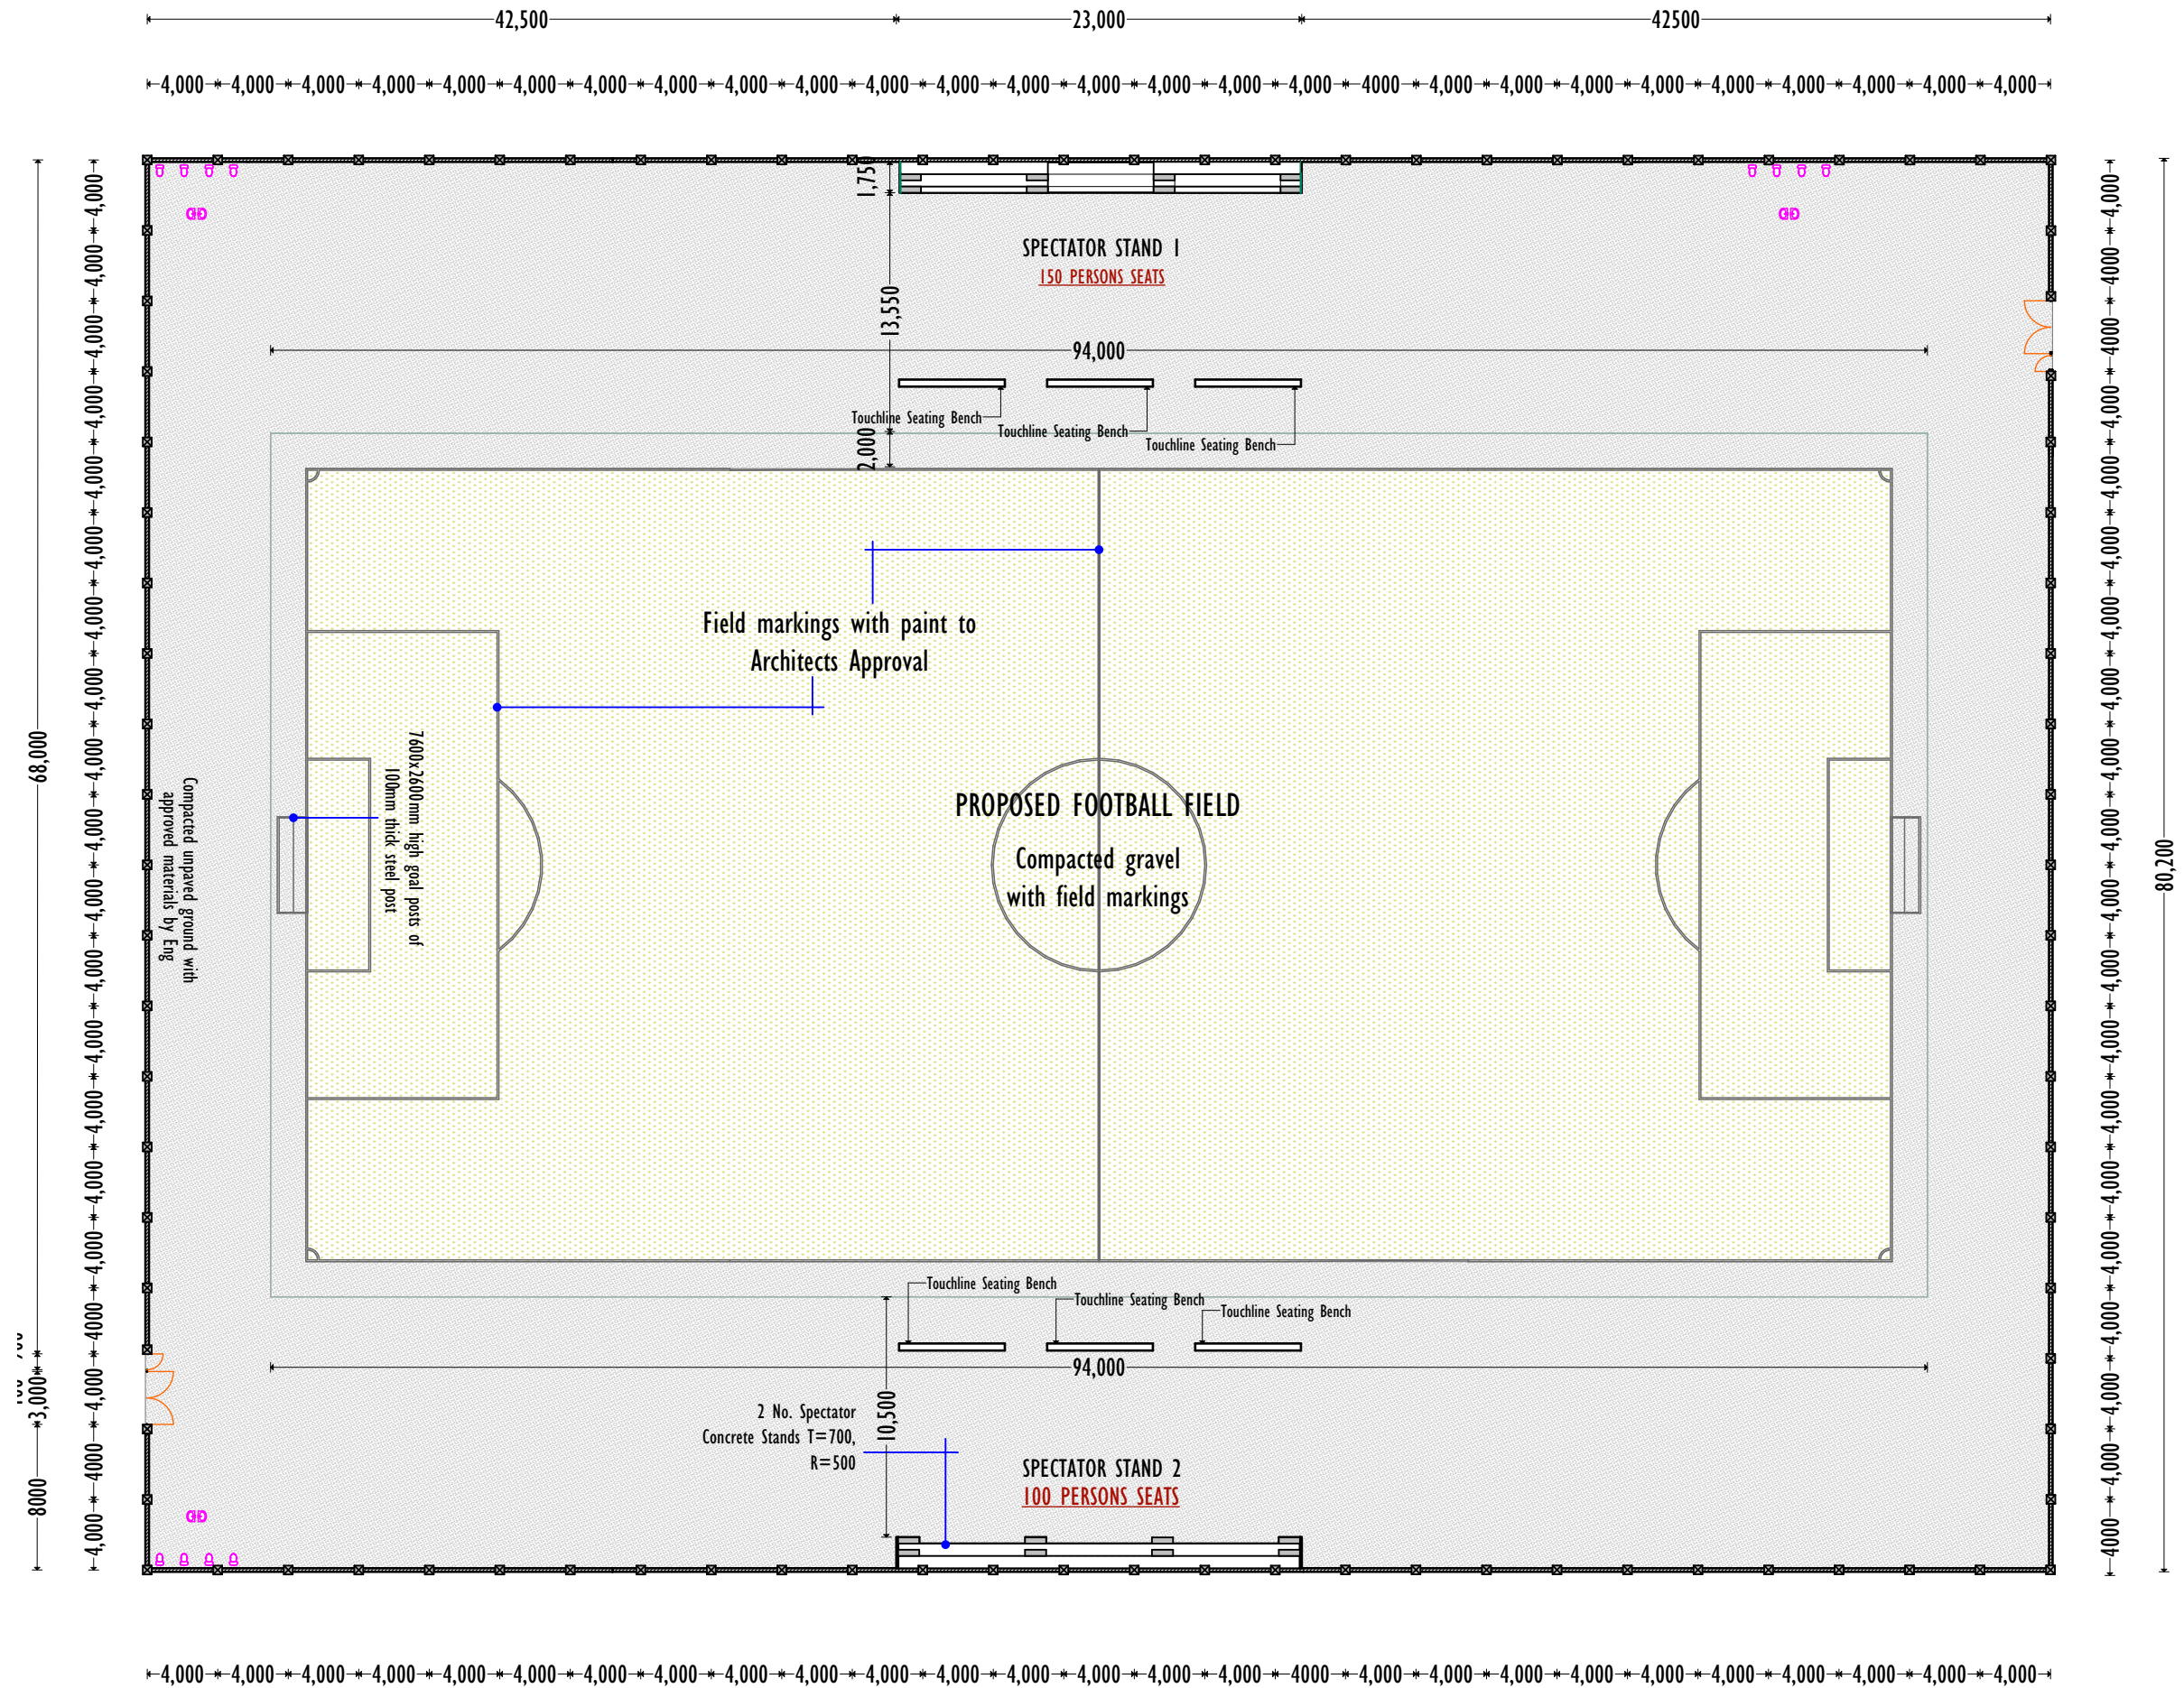

PROPOSED SITE PLAN

ARCHITECTS



GeConsult
ARCHITECTURE & ENGINEERING CONSULTANTS
Office No. 529,
5th Floor, 680 Hotel Building,
Muindi Mbingu Street,
Off Kenyatta Avenue,
geconsultteam@gmail.com
www.geconsultarchitects.com
P.O Box 103525 - 00101 Nairobi, Kenya
Tel: +254 724 008 839 / +254 725 178 875

PROJECT DETAILS

Client:



**SOUTH WEST
STATE
ADMINISTRATION**

Implementation Partner:

**SOMALIA STABILIZATION
INITIATIVE (SSI)**

Project title:

**PROPOSED GOOF GUDUUD
FOOTBALL FIELD**

Drawing Title:

SET OUT PLAN

Revision No.

01

Drawn by:

A.K.

Checked by:

Hassan Abdisamad

Sheet No.


03



Scale:




Date:

July 2017

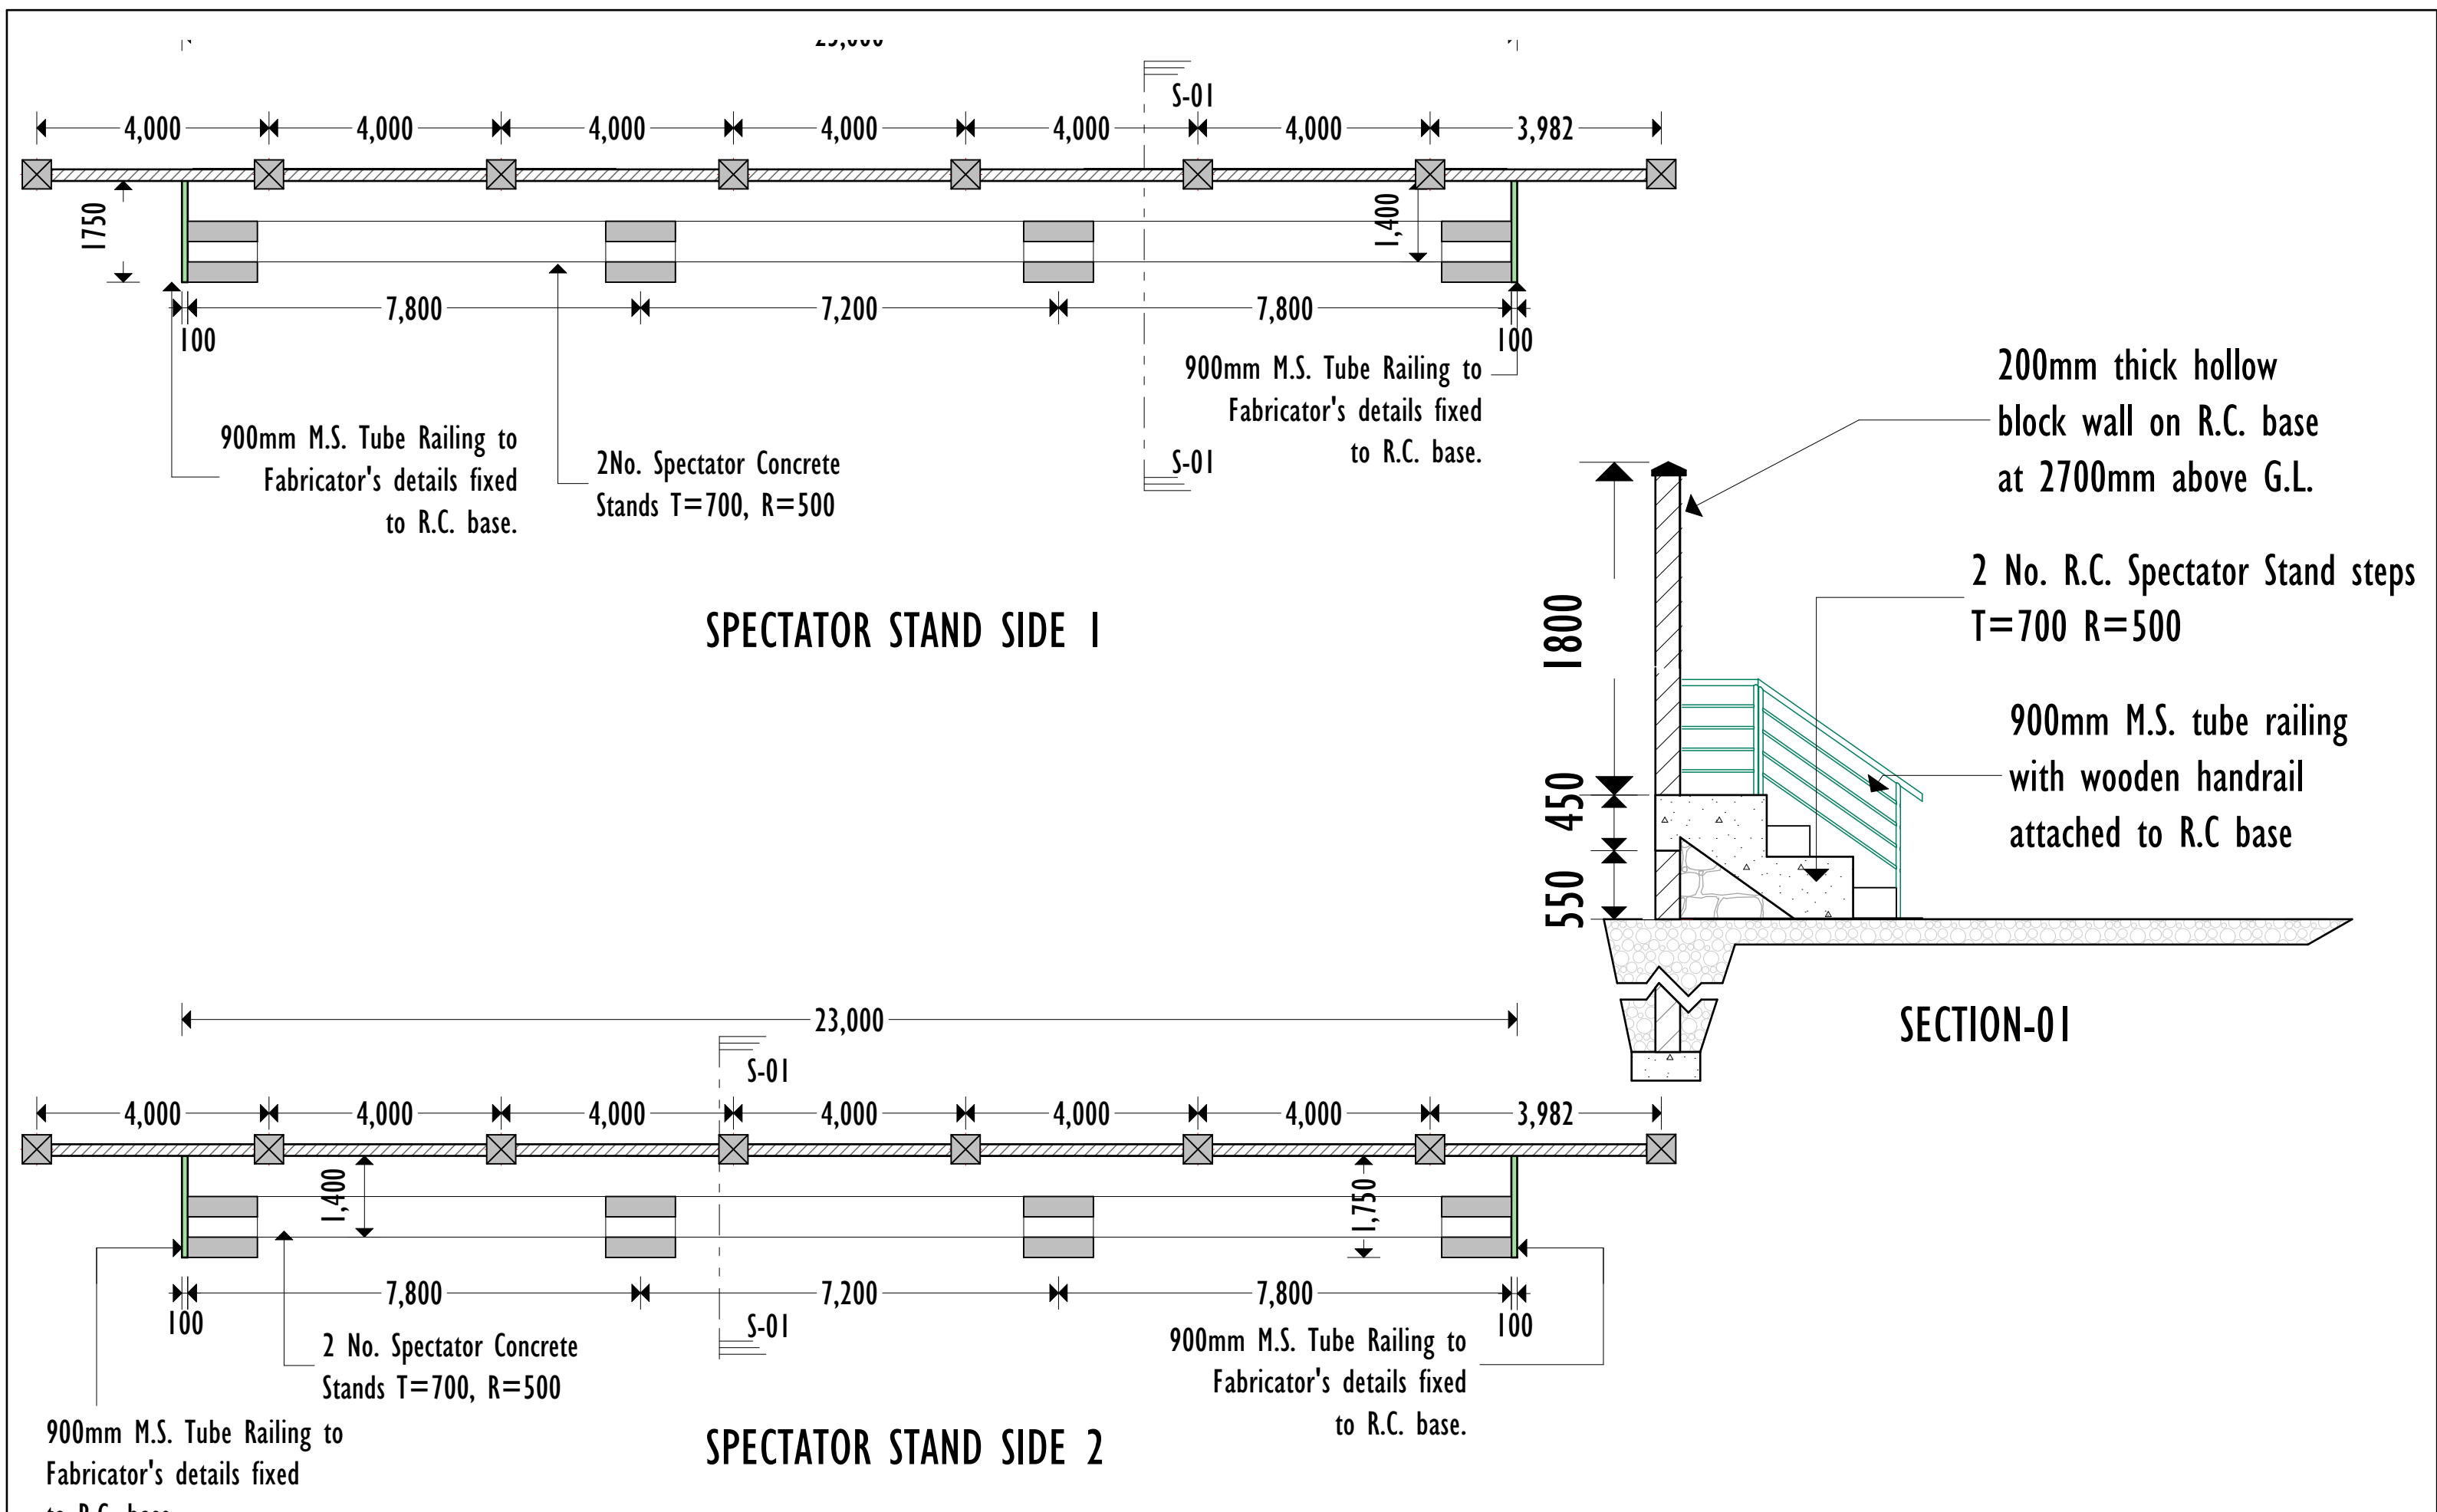ARCHITECTURAL DRAWINGS




ARCHITECTS		PROJECT DETAILS			Drawing Title:		Revision No.	
 GeConsult ARCHITECTURE & ENGINEERING CONSULTANTS <small>Office No. 529, 5th Floor, 680 Hotel Building, Muindi Mbingu Street, Off Kenyatta Avenue, geconsultteam@gmail.com www.geconsultarchitects.com P.O Box 103525 - 00101 Nairobi, Kenya Tel: +254 724 008 839 / +254 725 178 875</small>	Client:		Implementation Partner:	Project title:	SPECTATOR STAND		01	
	 SOUTH WEST STATE ADMINISTRATION		SOMALIA STABILIZATION INITIATIVE (SSI)		Drawn by:	Checked by:	Sheet No.	Scale:
					A.K.	Hassan Abdisamad	04	
					Date:	July 2017	ARCHITECTURAL DRAWINGS	

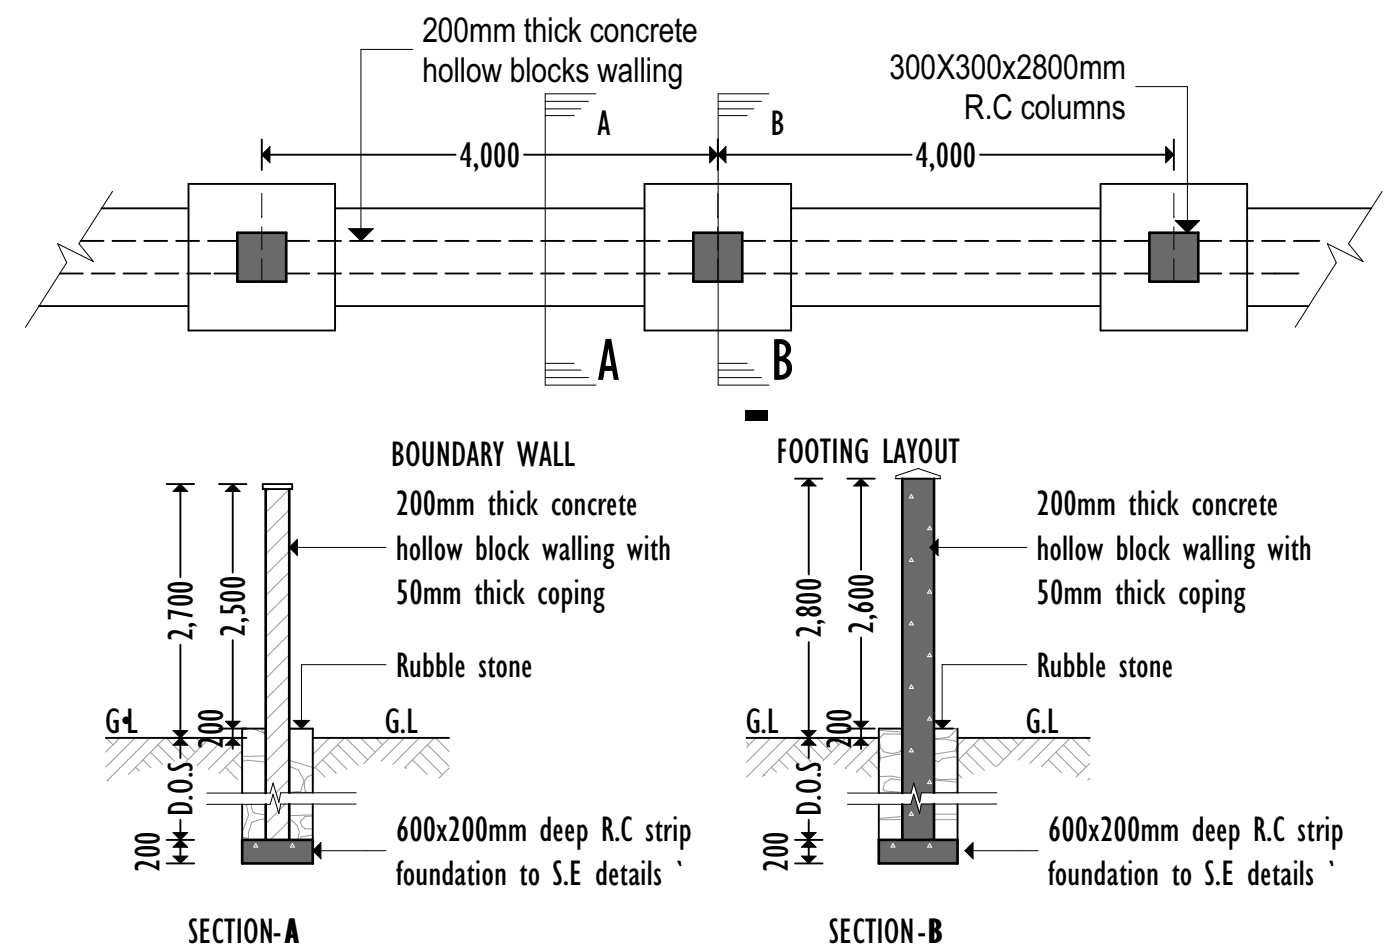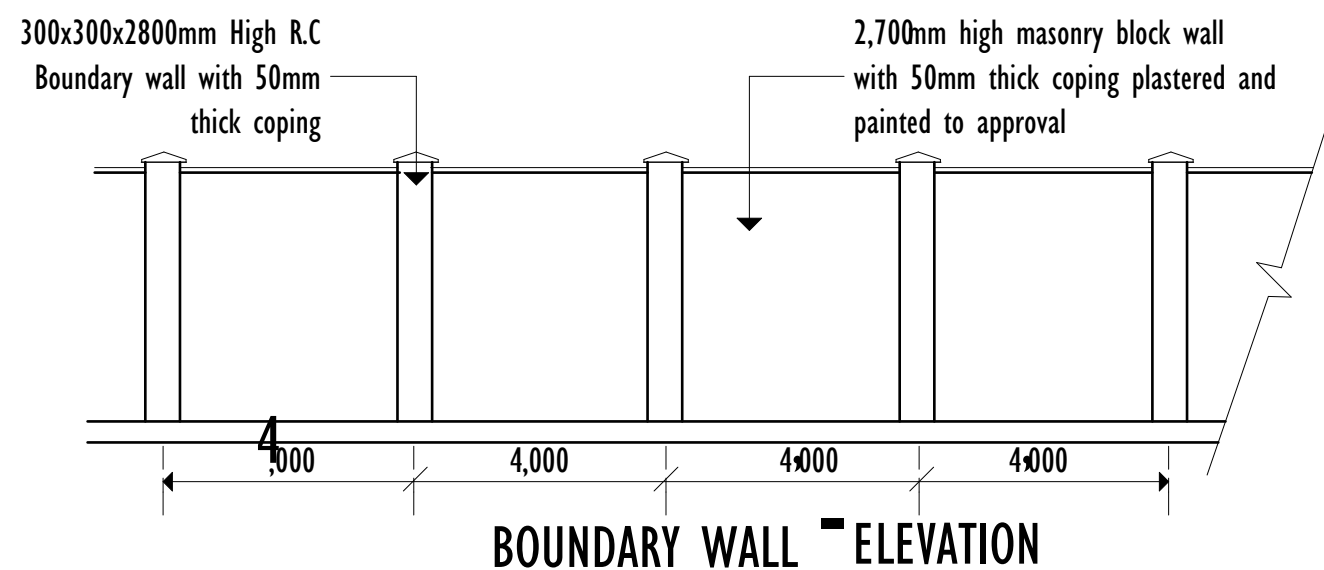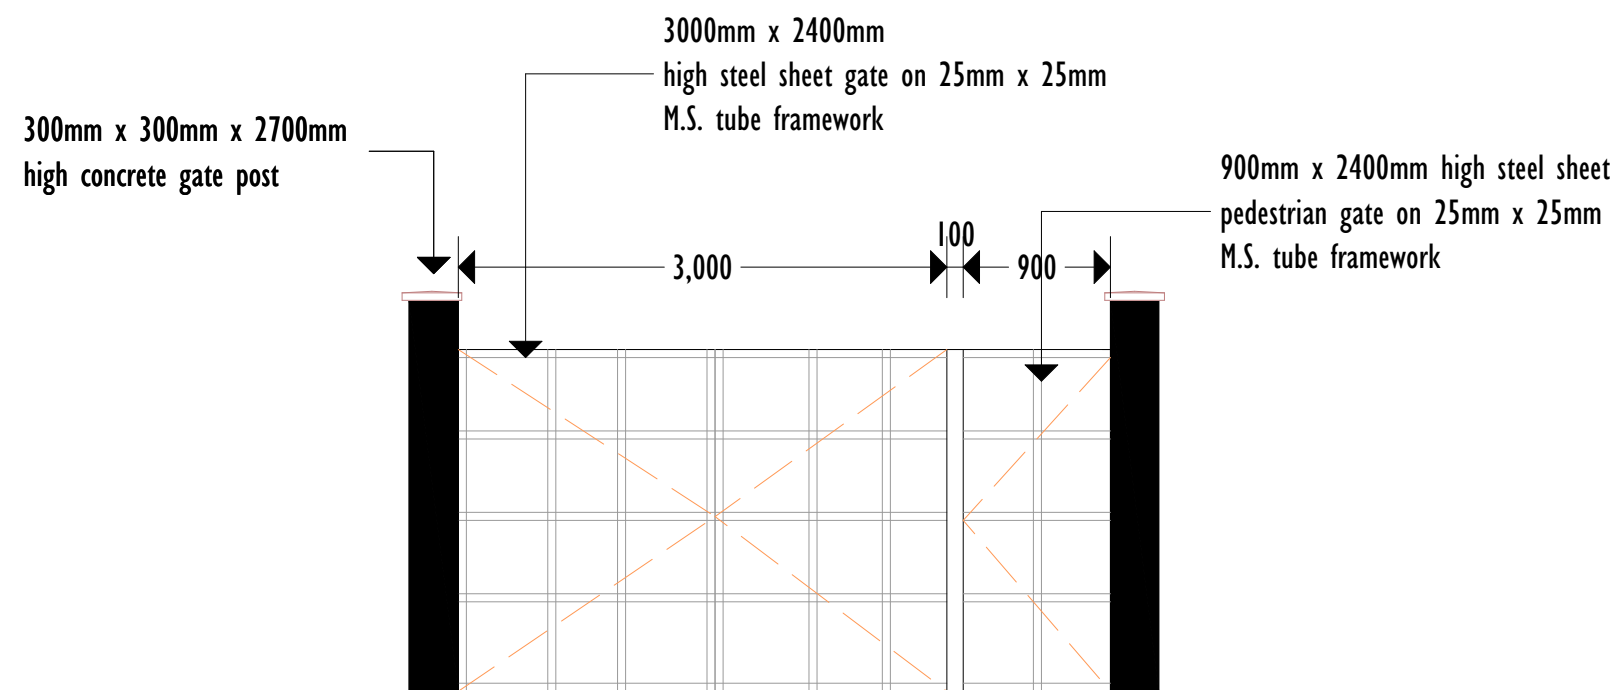

D.O.S
DETERMINED ON SITE MINIMUM OF 1000MM DEEP

ARCHITECTS

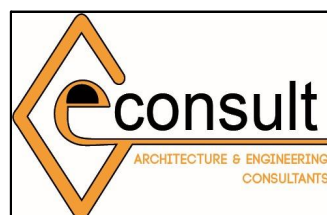

GeConsult

ARCHITECTURE & ENGINEERING CONSULTANTS

Office No. 529,
5th Floor, 680 Hotel Building,
Muindi Mbingu Street,
Off Kenyatta Avenue.

geconsultteam@gmail.com
www.geconsultarchitects.com
P.O Box 103525 - 00101 Nairobi, Kenya
Tel: +254 724 008 839 / +254 725 178 875

PROJECT DETAILS

Client:



SOUTH WEST
STATE
ADMINISTRATION

Project title:

REHABILITATION OF GOOF GUDUUD
FOOTBALL FIELD

Drawing Title:

FENCE DETAILS

Revision No.

--

Drawn by:

A.K.

Checked by:

HASSAN ABDISAMAD

Sheet No.


05

Scale:


Date:

July 2017

ELECTRICAL DRAWINGS

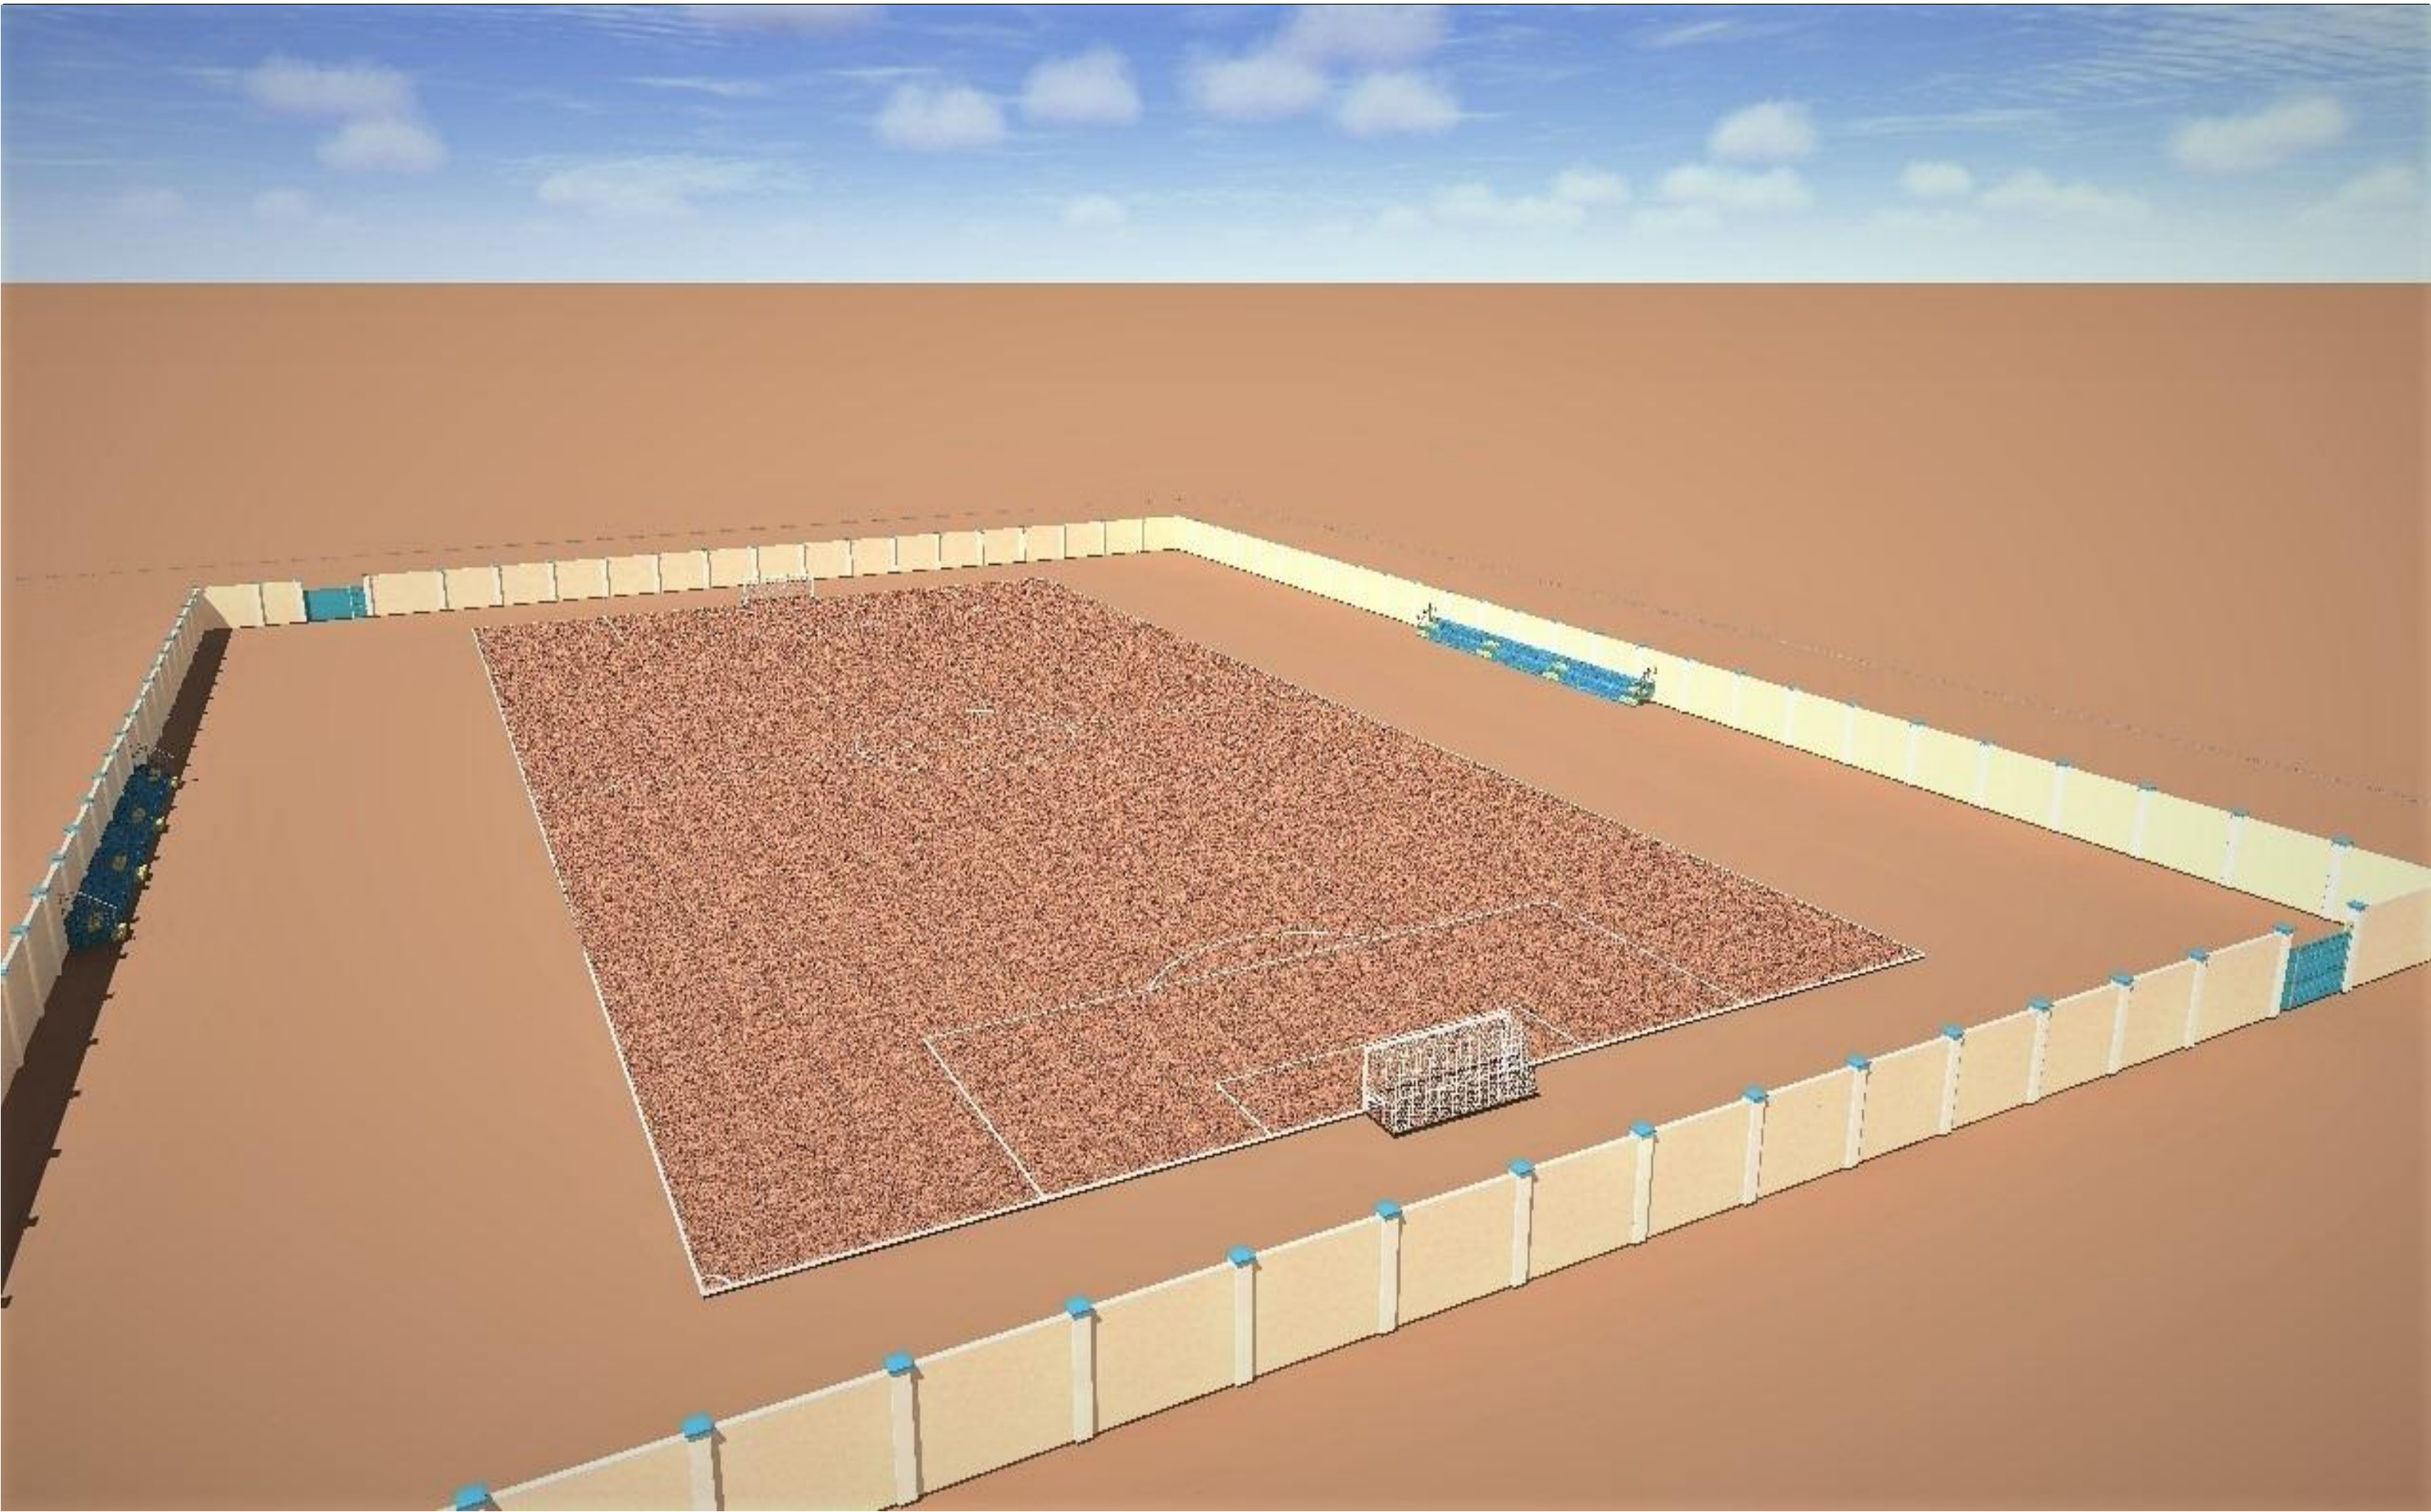

ARCHITECTS

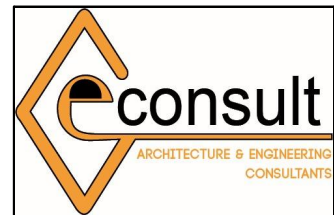

GeConsult
ARCHITECTURE & ENGINEERING CONSULTANTS
Office No. 529,
5th Floor, 680 Hotel Building,
Muindi Mbingu Street,
Off Kenyatta Avenue,
geconsultteam@gmail.com
www.geconsultarchitects.com
P.O Box 103525 - 00101 Nairobi, Kenya
Tel: +254 724 008 839 / +254 725 178 875

PROJECT DETAILS

Client:



**SOUTH WEST
STATE
ADMINISTRATION**


Implementation Partner:

**SOMALIA STABILIZATION
INITIATIVE (SSI)**


Project title:

**PROPOSED GOOF GUDUUD
FOOTBALL FIELD**

Drawing Title:		Revision No.	
3 DIMENSIONAL PROJECTION		01	
Drawn by:	Checked by:	Sheet No.	Scale:
A.K.	Hassan Abdisamad	3D-01	
Date:	July 2017	ARCHITECTURAL DRAWINGS	

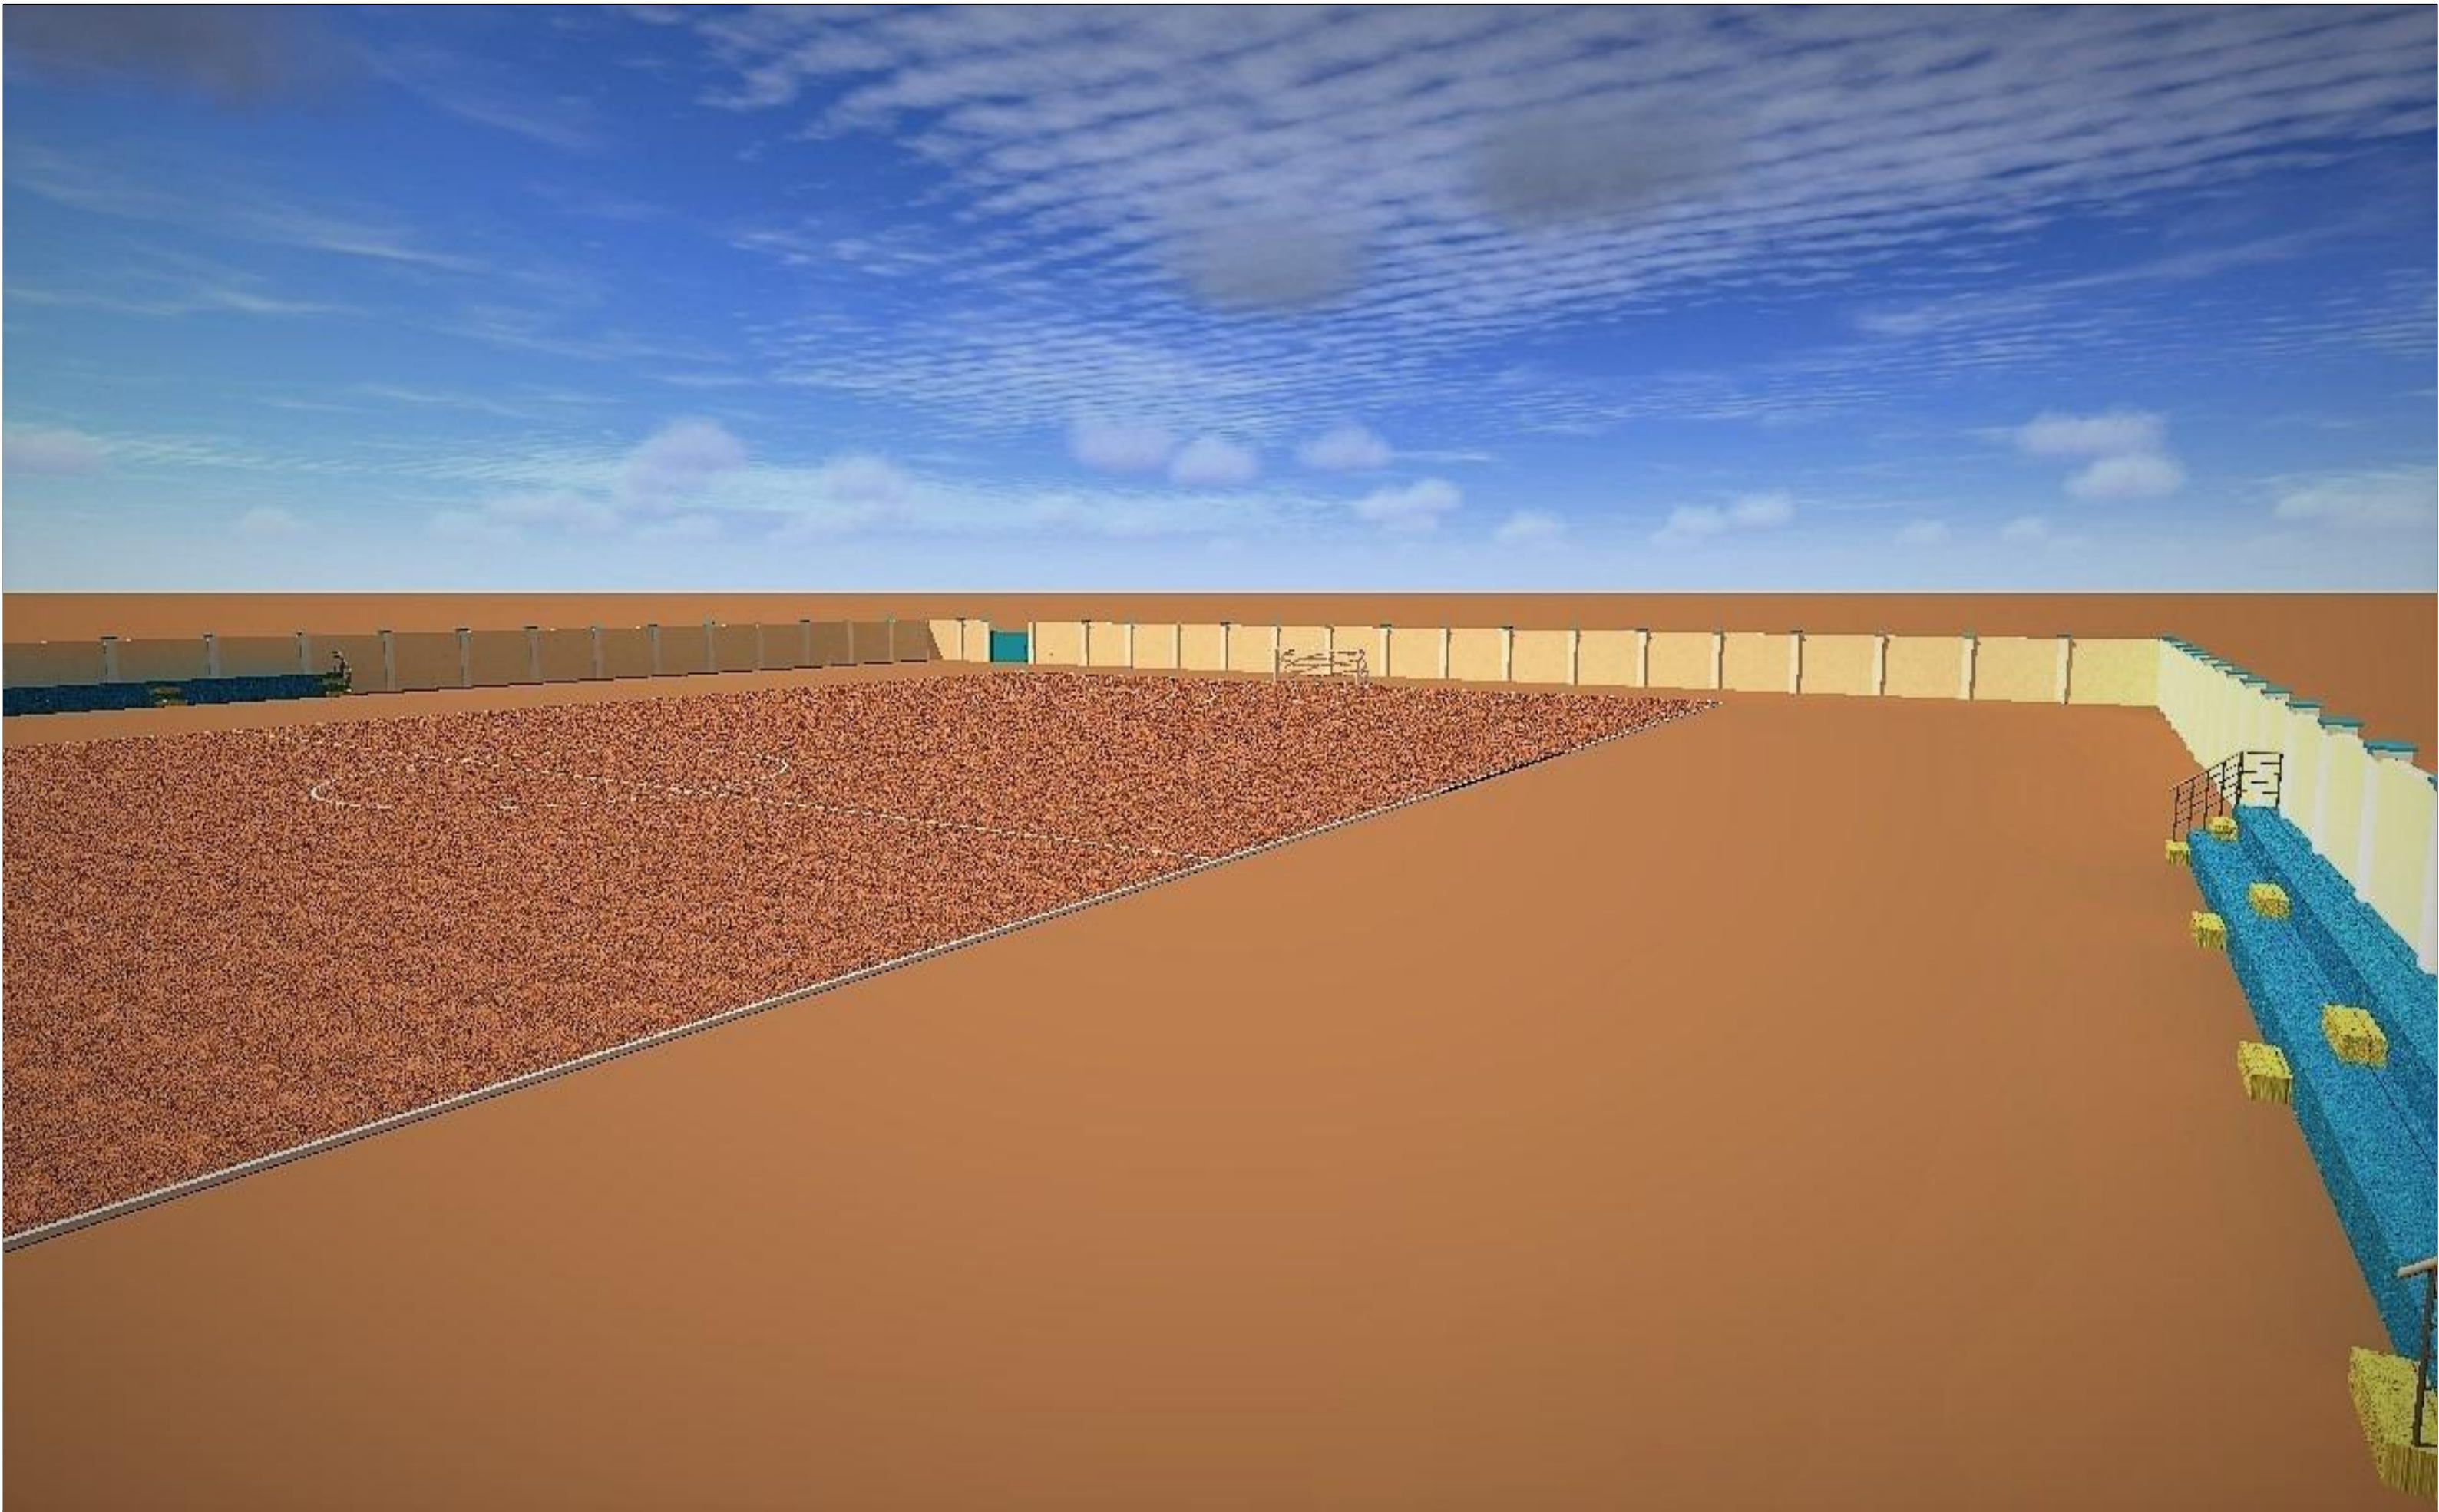

ARCHITECTS

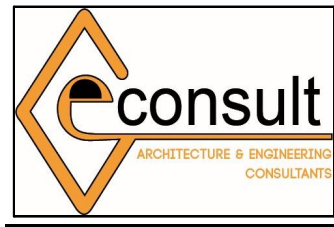

GeConsult
ARCHITECTURE & ENGINEERING CONSULTANTS
Office No. 529,
5th Floor, 680 Hotel Building,
Muindi Mbingu Street,
Off Kenyatta Avenue,
geconsultteam@gmail.com
www.geconsultarchitects.com
P.O Box 103525 - 00101 Nairobi, Kenya
Tel: +254 724 008 839 / +254 725 178 875

PROJECT DETAILS

Client:
 **SOUTH WEST
STATE
ADMINISTRATION**

Implementation Partner:
**SOMALIA STABILIZATION
INITIATIVE (SSI)**

Project title:
**PROPOSED GOOF GUDUUD
FOOTBALL FIELD**

Drawing Title:
3 DIMENSIONAL PROJECTION

Revision No.
01

Drawn by:
A.K.


Checked by:
Hassan Abdisamad

Sheet No.
3D-02


Scale:

Date: **July 2017**

ARCHITECTURAL DRAWINGS

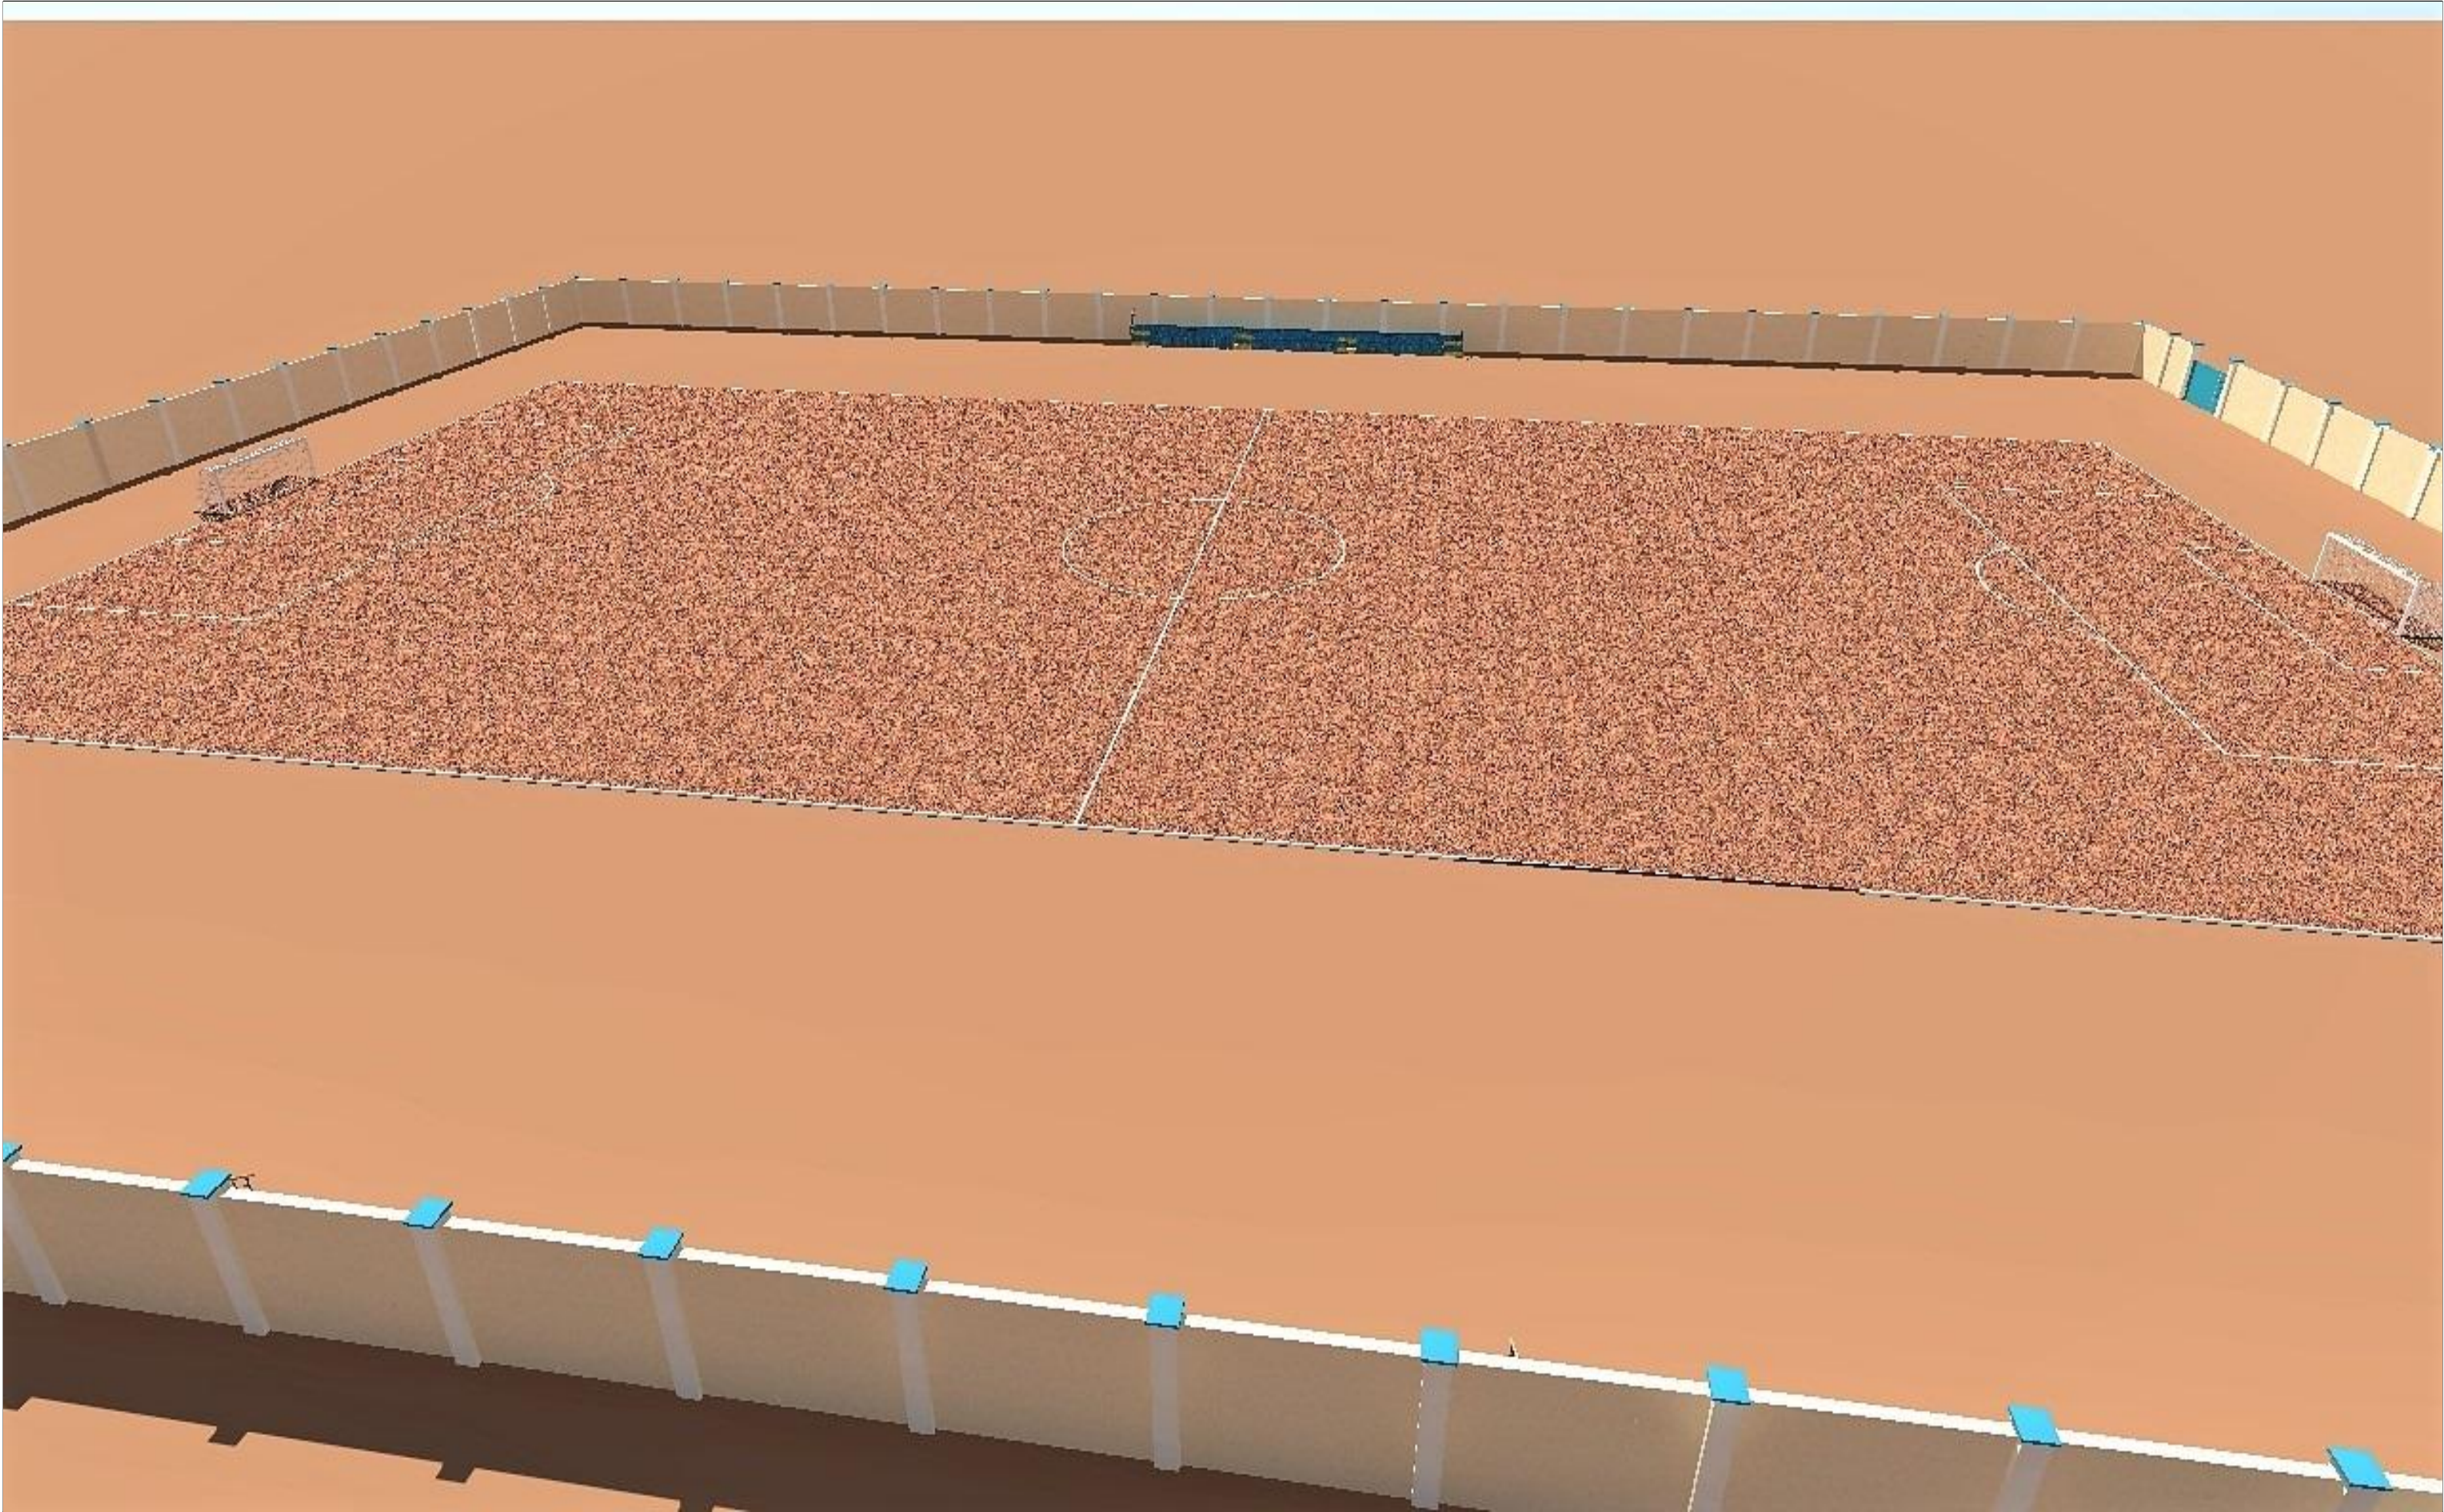

ARCHITECTS

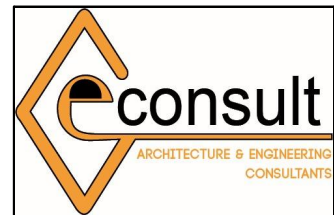

GeConsult
ARCHITECTURE & ENGINEERING CONSULTANTS
Office No. 529,
5th Floor, 680 Hotel Building,
Muindi Mbingu Street,
Off Kenyatta Avenue,
geconsultteam@gmail.com
www.geconsultarchitects.com
P.O Box 103525 - 00101 Nairobi, Kenya
Tel: +254 724 008 839 / +254 725 178 875

PROJECT DETAILS

Client:



**SOUTH WEST
STATE
ADMINISTRATION**

Implementation Partner:

**SOMALIA STABILIZATION
INITIATIVE (SSI)**


Project title:

**PROPOSED GOOF GUDUUD
FOOTBALL FIELD**

Drawing Title:		Revision No.	
3 DIMENSIONAL PROJECTION		01	
Drawn by:	Checked by:	Sheet No.	Scale:
A.K.	Hassan Abdisamad	3D-03	
Date:	July 2017	ARCHITECTURAL DRAWINGS	



ARCHITECTS

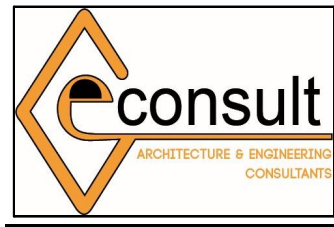


GeConsult
ARCHITECTURE & ENGINEERING CONSULTANTS
Office No. 529,
5th Floor, 680 Hotel Building,
Muindi Mbingu Street,
Off Kenyatta Avenue,
geconsultteam@gmail.com
www.geconsultarchitects.com
P.O Box 103525 - 00101 Nairobi, Kenya
Tel: +254 724 008 839 / +254 725 178 875

PROJECT DETAILS

Client:




Implementation Partner:

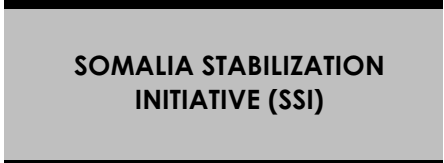


Project title:



Drawing Title:		Revision No.	
3 DIMENSIONAL PROJECTION		01	
Drawn by:	Checked by:	Sheet No.	Scale:
A.K.	Hassan Abdisamad	3D-04	
Date:	July 2017	ARCHITECTURAL DRAWINGS	

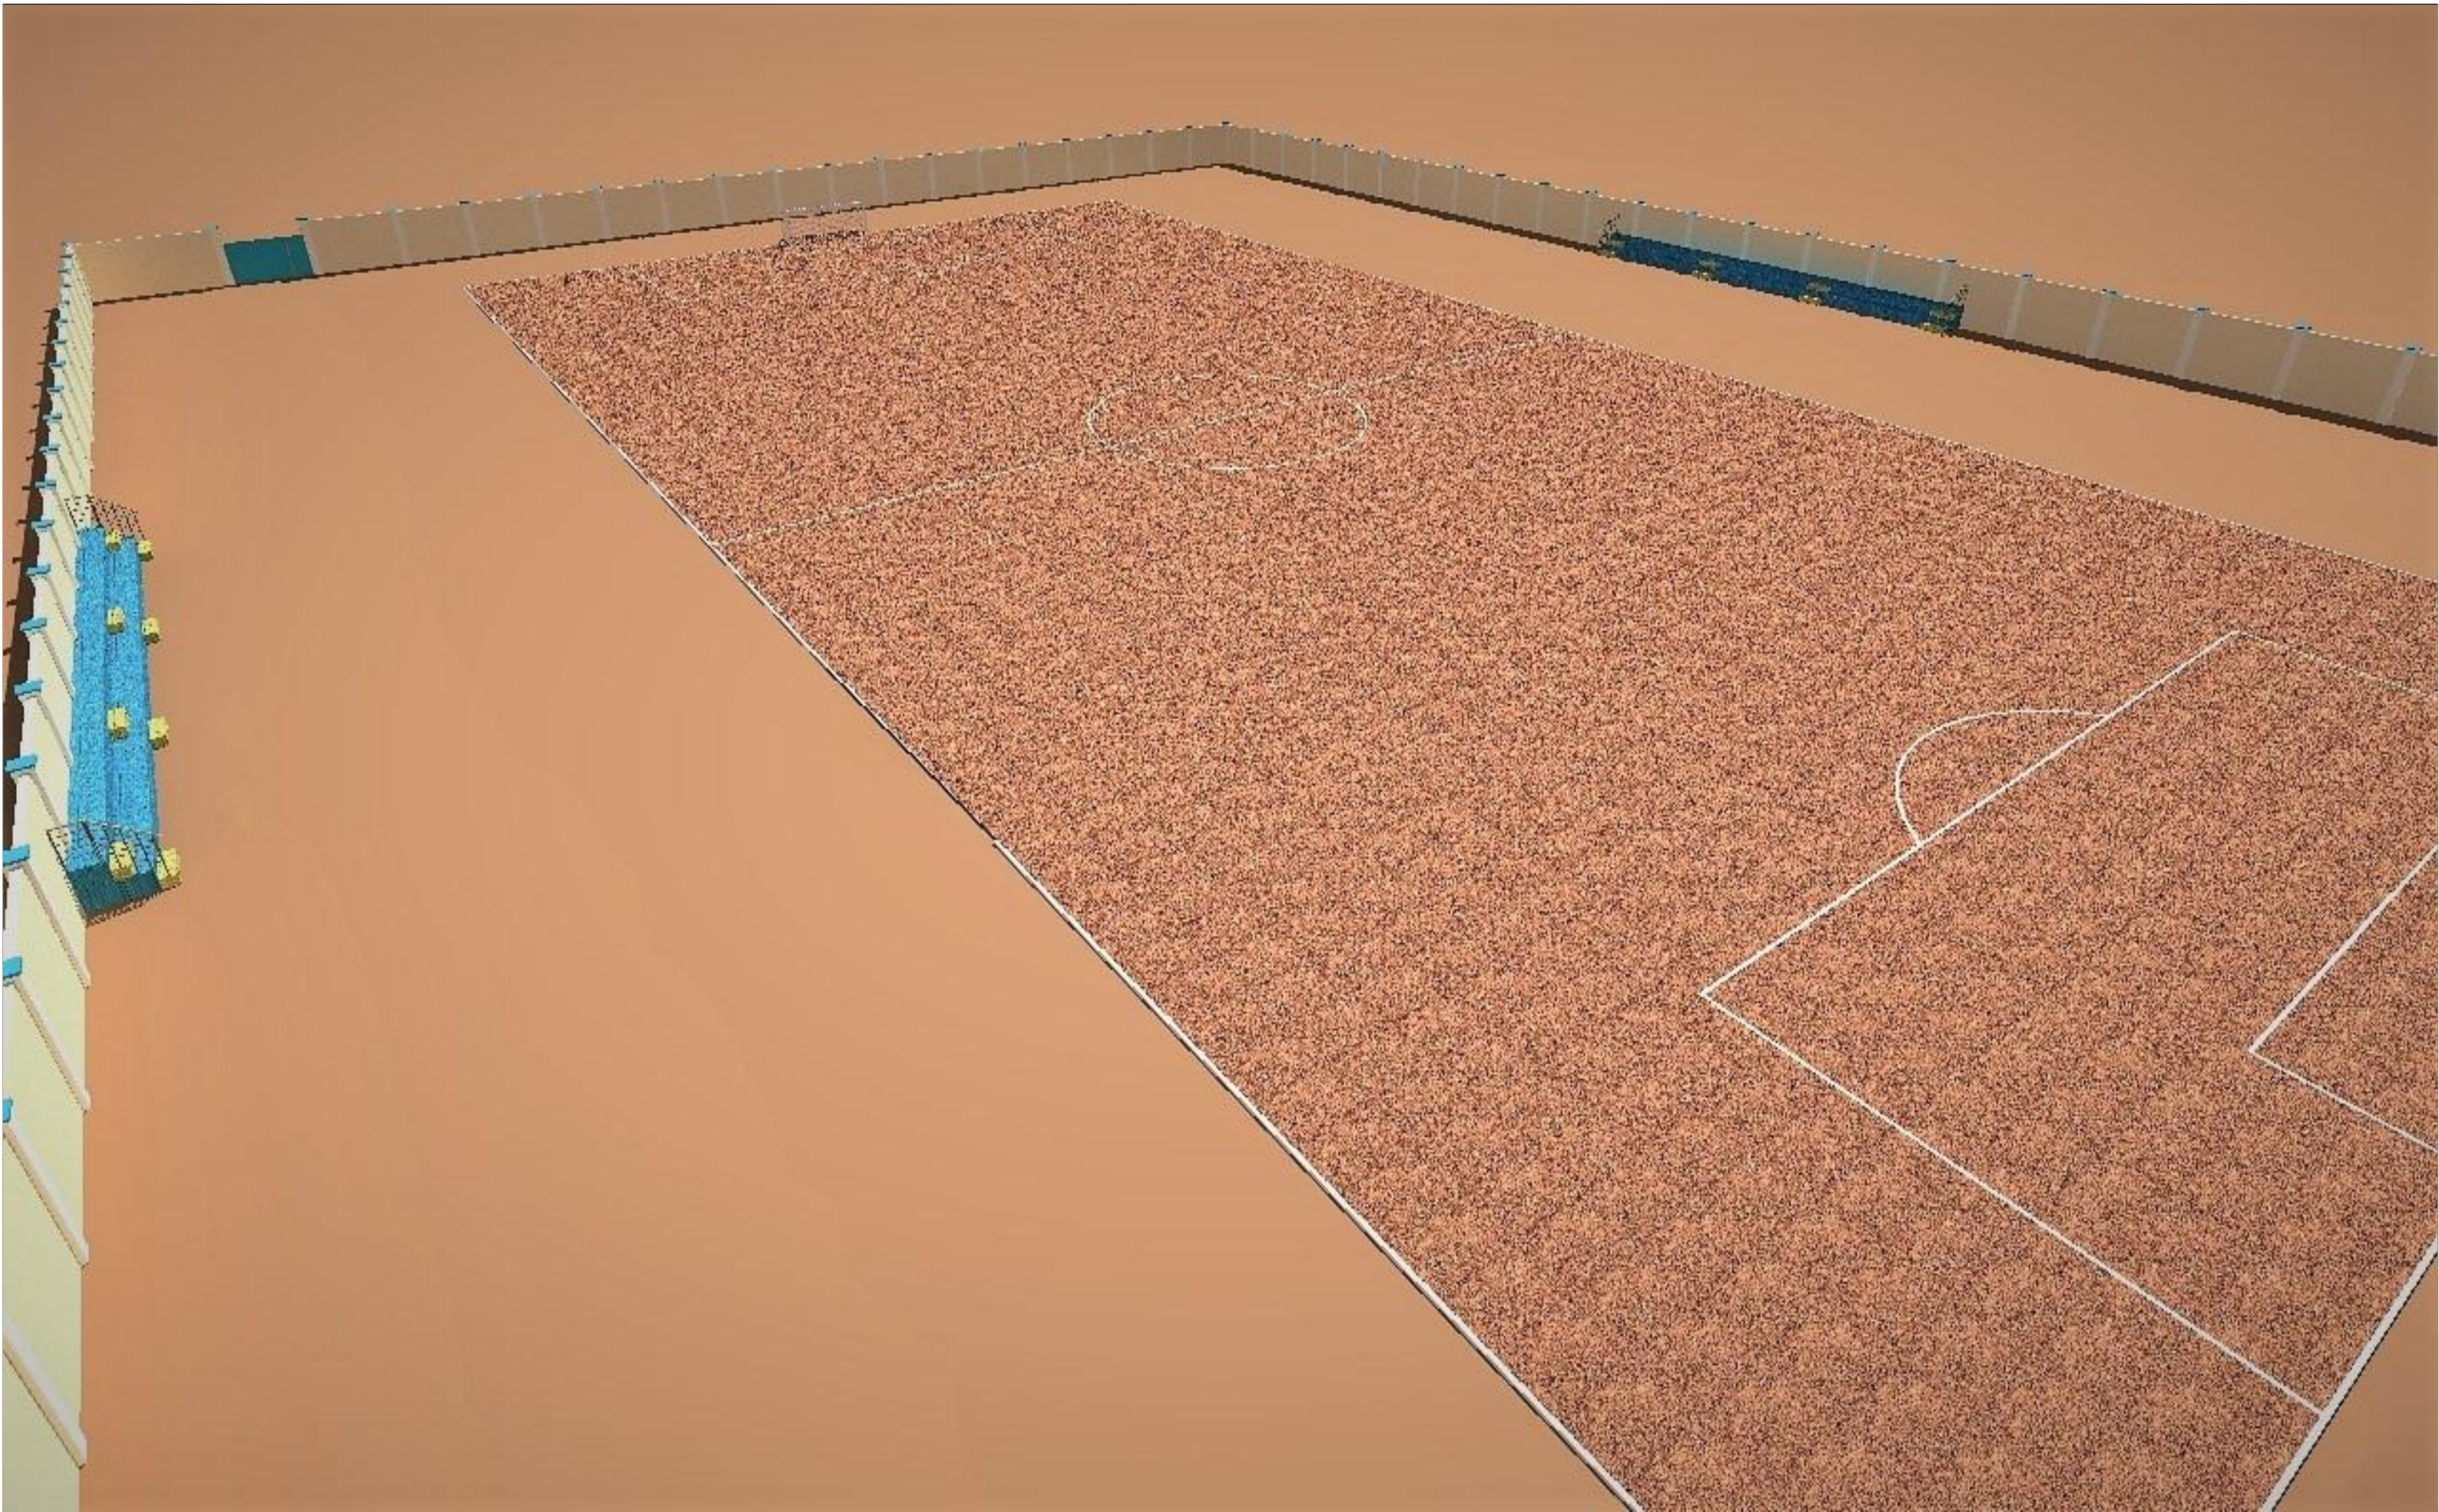

ARCHITECTS

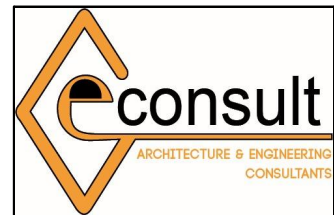

GeConsult
ARCHITECTURE & ENGINEERING CONSULTANTS
Office No. 529,
5th Floor, 680 Hotel Building,
Muindi Mbingu Street,
Off Kenyatta Avenue,
geconsultteam@gmail.com
www.geconsultarchitects.com
P.O Box 103525 - 00101 Nairobi, Kenya
Tel: +254 724 008 839 / +254 725 178 875

PROJECT DETAILS

Client:



**SOUTH WEST
STATE
ADMINISTRATION**

Implementation Partner:

**SOMALIA STABILIZATION
INITIATIVE (SSI)**

Project title:

**PROPOSED GOOF GUDUUD
FOOTBALL FIELD**

Drawing Title:		Revision No.	
3 DIMENSIONAL PROJECTION		01	
Drawn by:	Checked by:	Sheet No.	Scale:
A.K.	Hassan Abdisamad	3D-05	
Date:	July 2017	ARCHITECTURAL DRAWINGS	